



VANZUELLA

Vanzuella Company For Consulting Engineering Designs



Owner Name	الشركة العامة الاردنية للصوامع والتموين المساهمة العامة المحدودة.		
Site	ALRSAYFEH	Date	10-2025
Basin Name-No	-----	Land Area	-----
Plot Number	-----	Regulation	-----

Architect	Civil Engineer
Arch.Suhil Ajelat	Najih Kanaan
200097	101135
Electrical Engineer	Mechanical Engineer
Shatha Alkarareh	Azzam Attari
411388	300760

Mobile Number
0799933707

All rights reserved. No part of this blueprint may be reproduced , distributed, or transmitted in any form or by any means , including photocopying, recording, or other electronic or mechanical methods , without the prior written permission of the respective architectural firm .

PROPOSED HANGAR CONTAIN : PROPOSED (GROUND FLOOR)

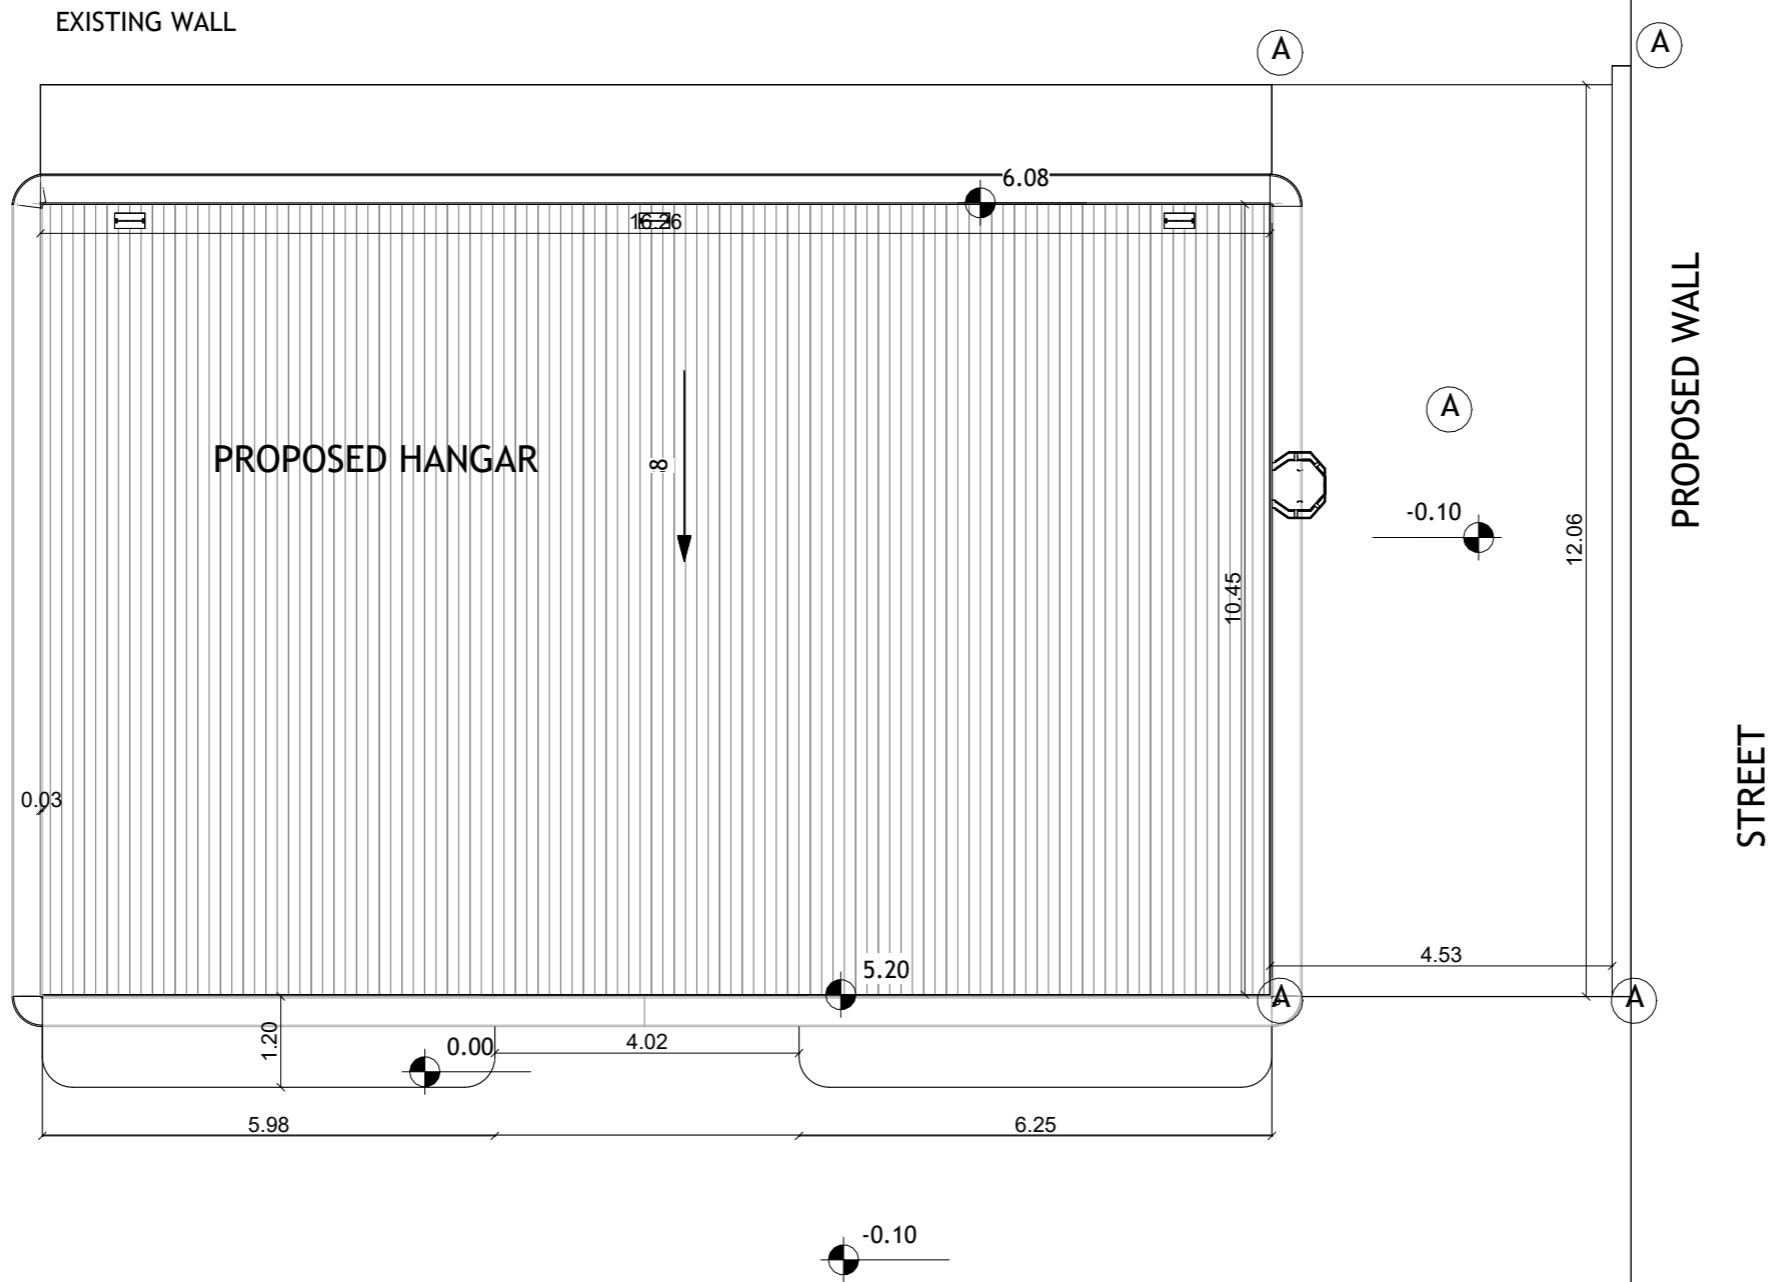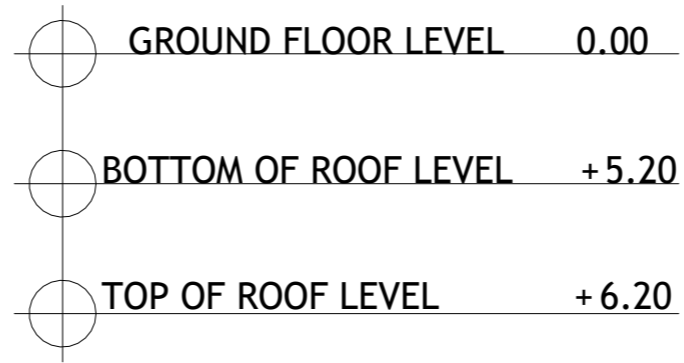

VANZUELLA

Vanzulla Company For Consulting
 Engineering Designs
 (2824)
 Tel- 0789695422

Plot No.	Basin No.	Basin name	The village

Client Name
 الشركة العامة الاردنية للصوامع والتموين المساهمة
 العامة المحدودة.
 Project Name

SITE PLAN

Project number 306

Date Issue Date



Design by : Arch. Shahed 218190

Checked by : Arch. Suhail 200097

A101

Scale 1:100

PROPOSED HANGAR CONTAIN : PROPOSED (GROUND FLOOR)

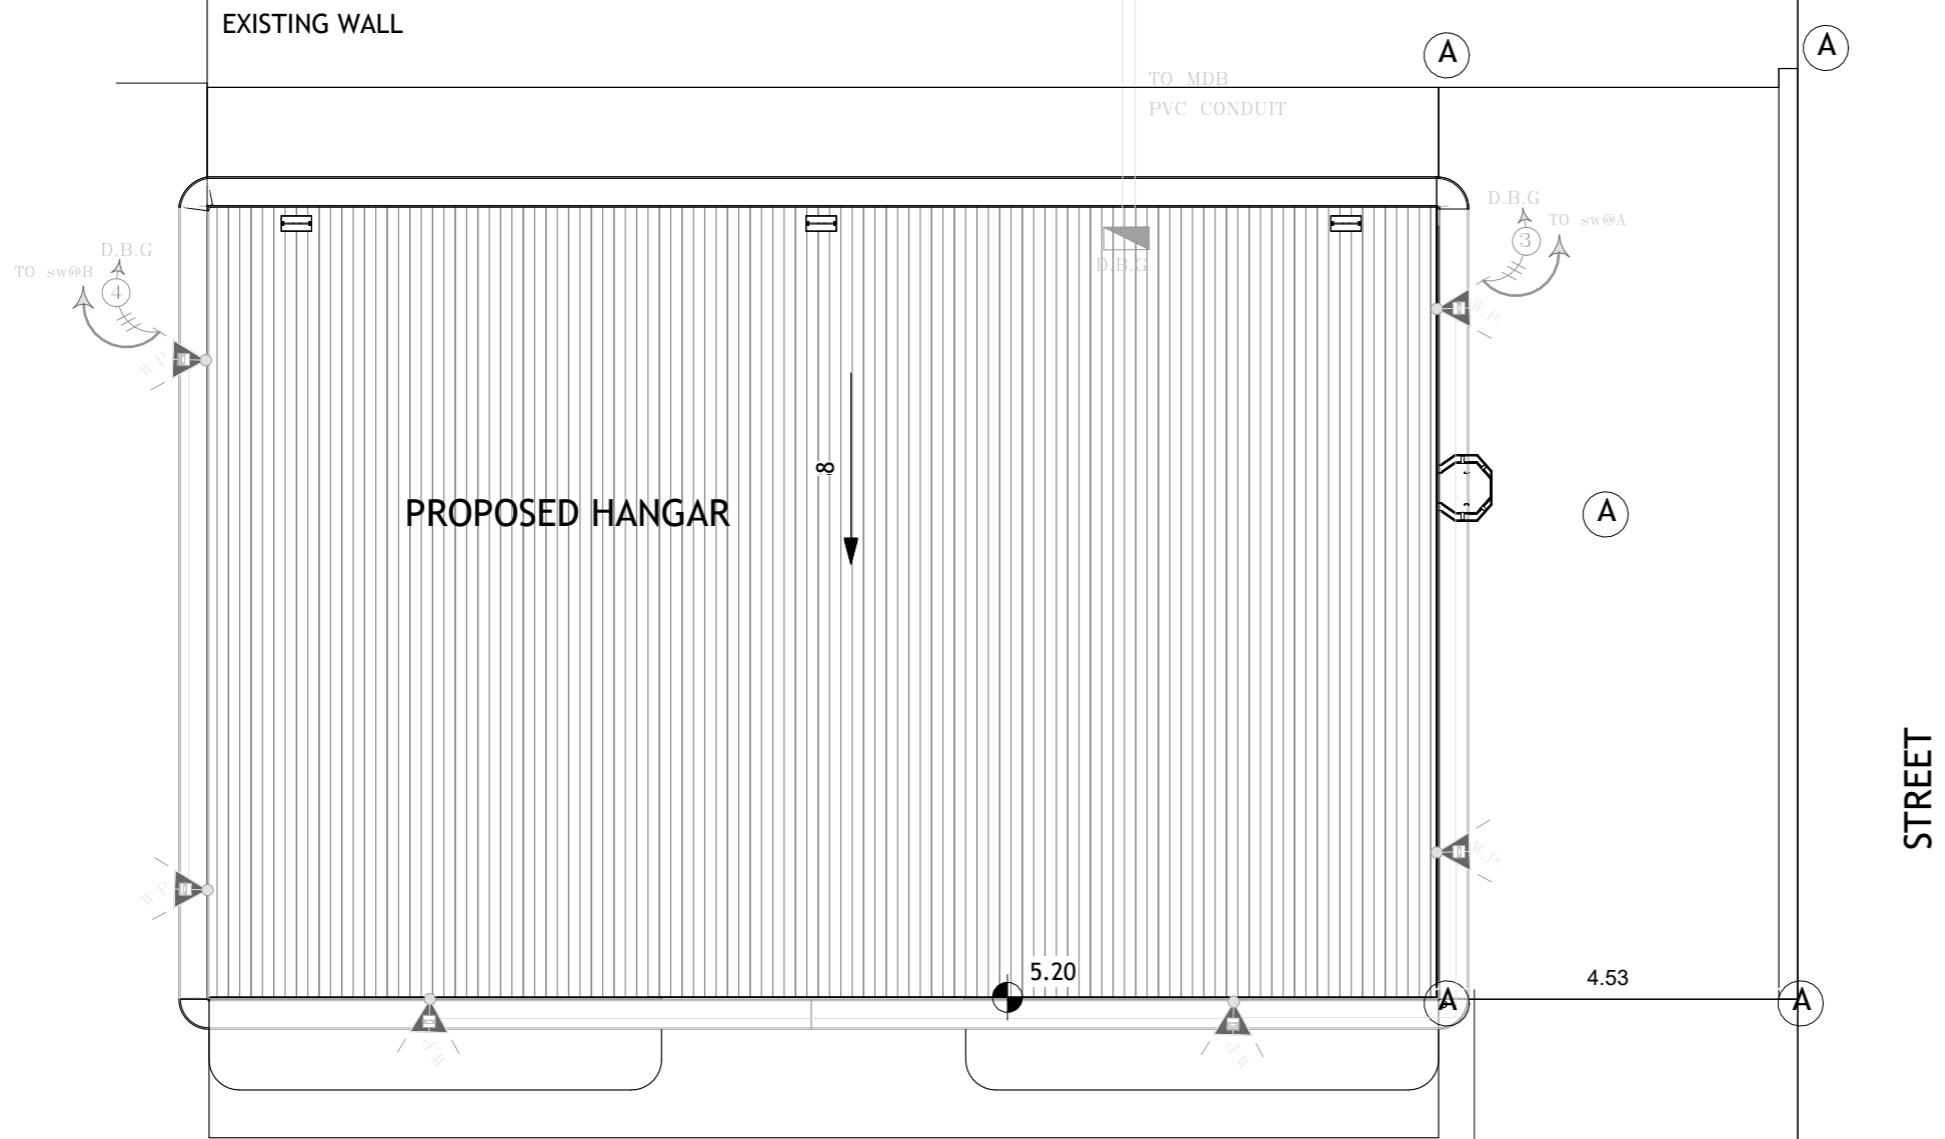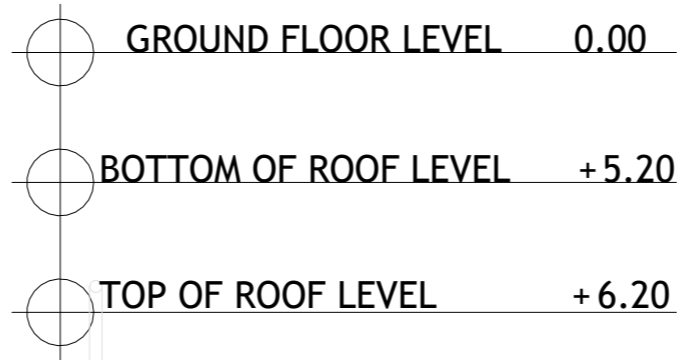

VANZUELLA

Vanzulla Company For Consulting
Engineering Designs
(2824)

Tel- 0789695422

Plot No.	Basin No.	Basin name	The village

Client Name
الشركة العامة الاردنية للصوامع والتموين المساهمة
العامة المحدودة.

Project Name

SITE PLAN WITH SERVICES

Project number 306

Date Issue Date

Design by : Arch.Shahed 218190

Checked by : Arch.Suhail 200097

A101.5


Scale 1:100



VANZUELLA

Vanzulla Company For Consulting
Engineering Designs
(2824)

Tel- 0789695422

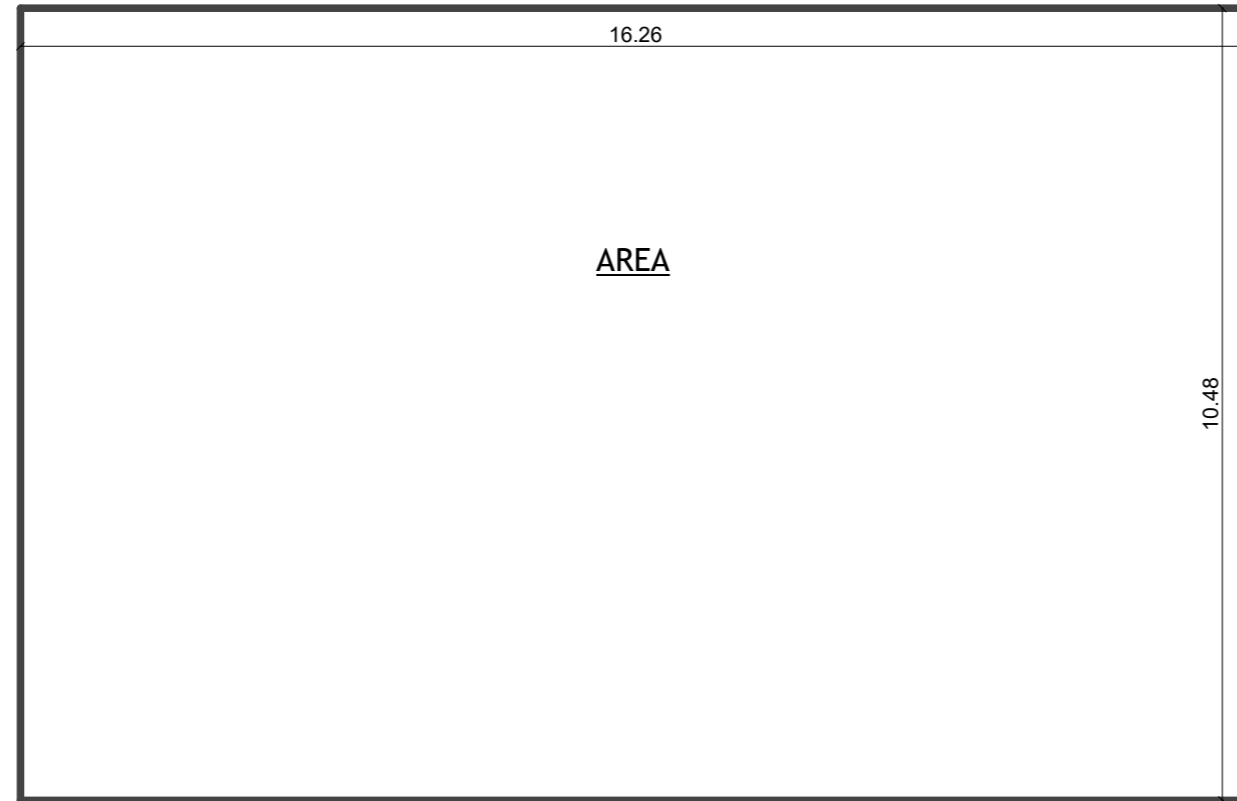

Area Schedule (Rentable)		
Name	Comments	Area

AREA	16.26*12.069	170.36 m ²
------	--------------	-----------------------

Total Area= 170.36 m²

Plot No.	Basin No.	Basin name	The village
----------	-----------	------------	-------------

--	--	--	--

Client Name
الشركة العامة الاردنية للصوامع والتموين المساهمة
العامة المحدودة.

Project Name

AREA PLAN

Project number 306

Date Issue Date

Design by : Arch. Shahed 218190

Checked by : Arch. Suhail 200097

A102


Scale 1:100



VANZUELLA

Vanzulla Company For Consulting
Engineering Designs
(2824)

Tel- 0789695422

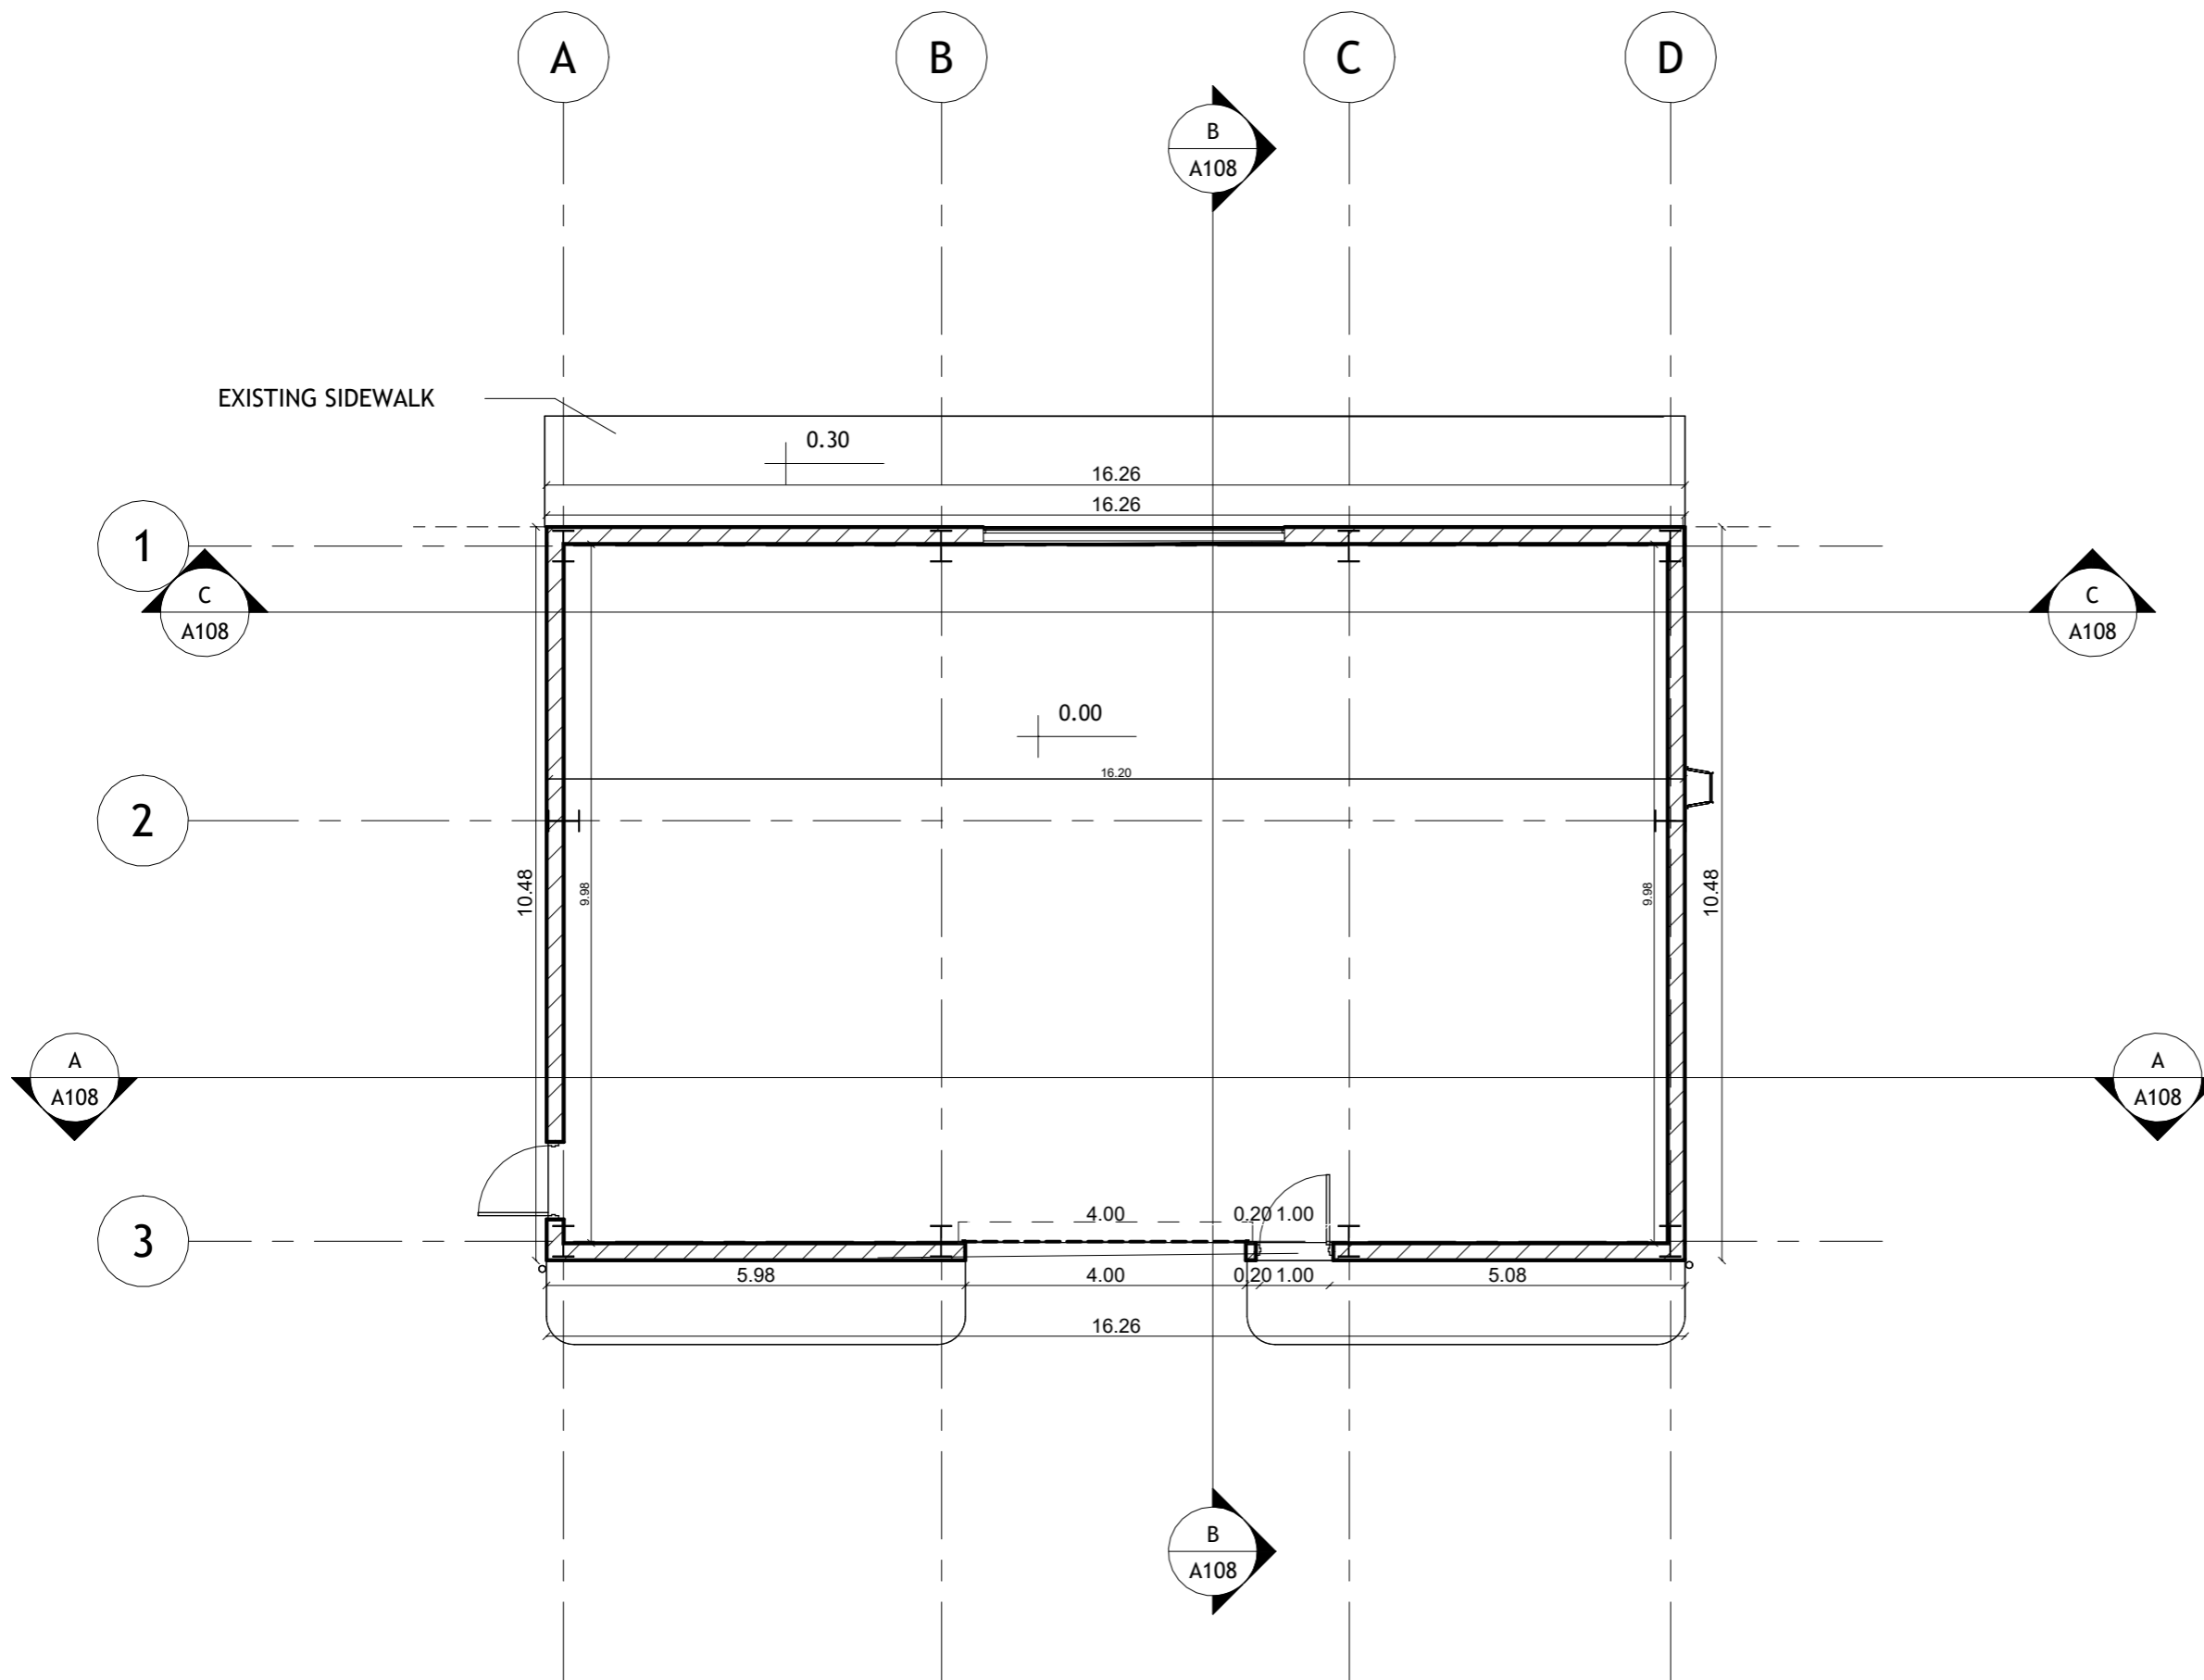

Plot No.	Basin No.	Basin name	The village

--	--	--	--

Client Name
 الشركة العامة الأردنية للصوامع والتموين المساهمة
 العامة المحدودة.
 Project Name

GROUND FLOOR

Project number 306

Date Issue Date

Design by : Arch. Shahed 218190

Checked by : Arch. Suhail 200097

A103

Scale 1:100





VANZUELLA

Vanzulla Company For Consulting
Engineering Designs
(2824)

Tel- 0789695422

ANCHOR HOOK

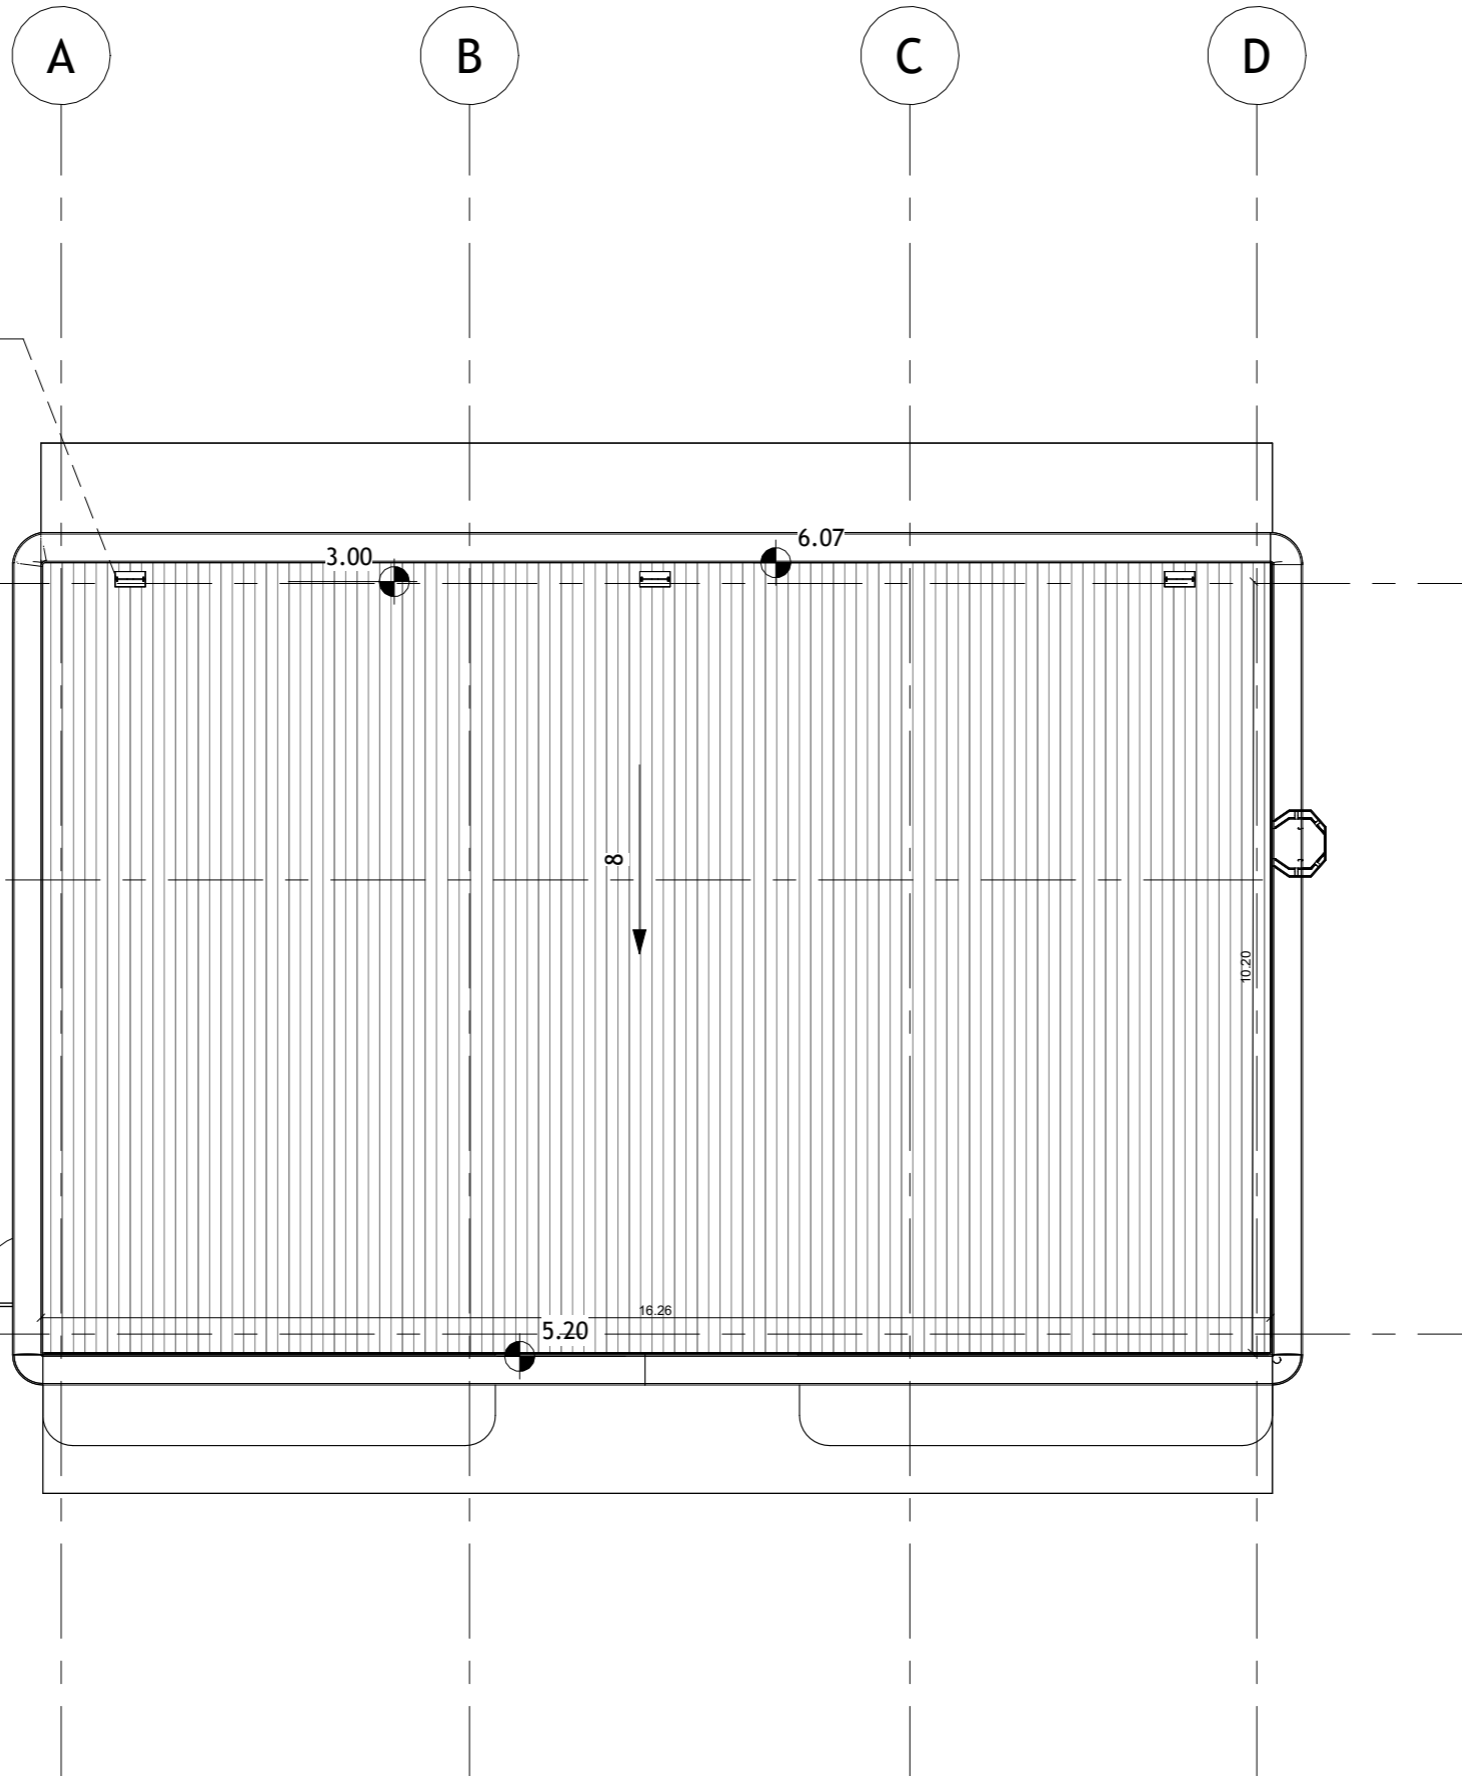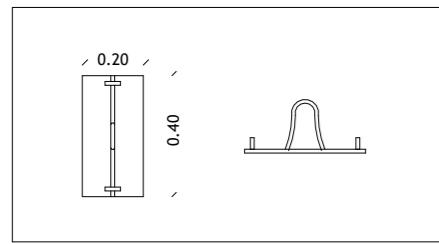

Plot No. Basin No. Basin name The village

--	--	--	--

Client Name
الشركة العامة الاردنية للصوامع والتموين المساهمة
العامة المحدودة.
Project Name

TOP OF ROOF

Project number 306

Date Issue Date

Design by : Arch. Shahed 218190

Checked by : Arch. Suhail 200097

A104


Scale 1:100



VANZUELLA

Vanzulla Company For Consulting
Engineering Designs
(2824)

Tel- 0789695422

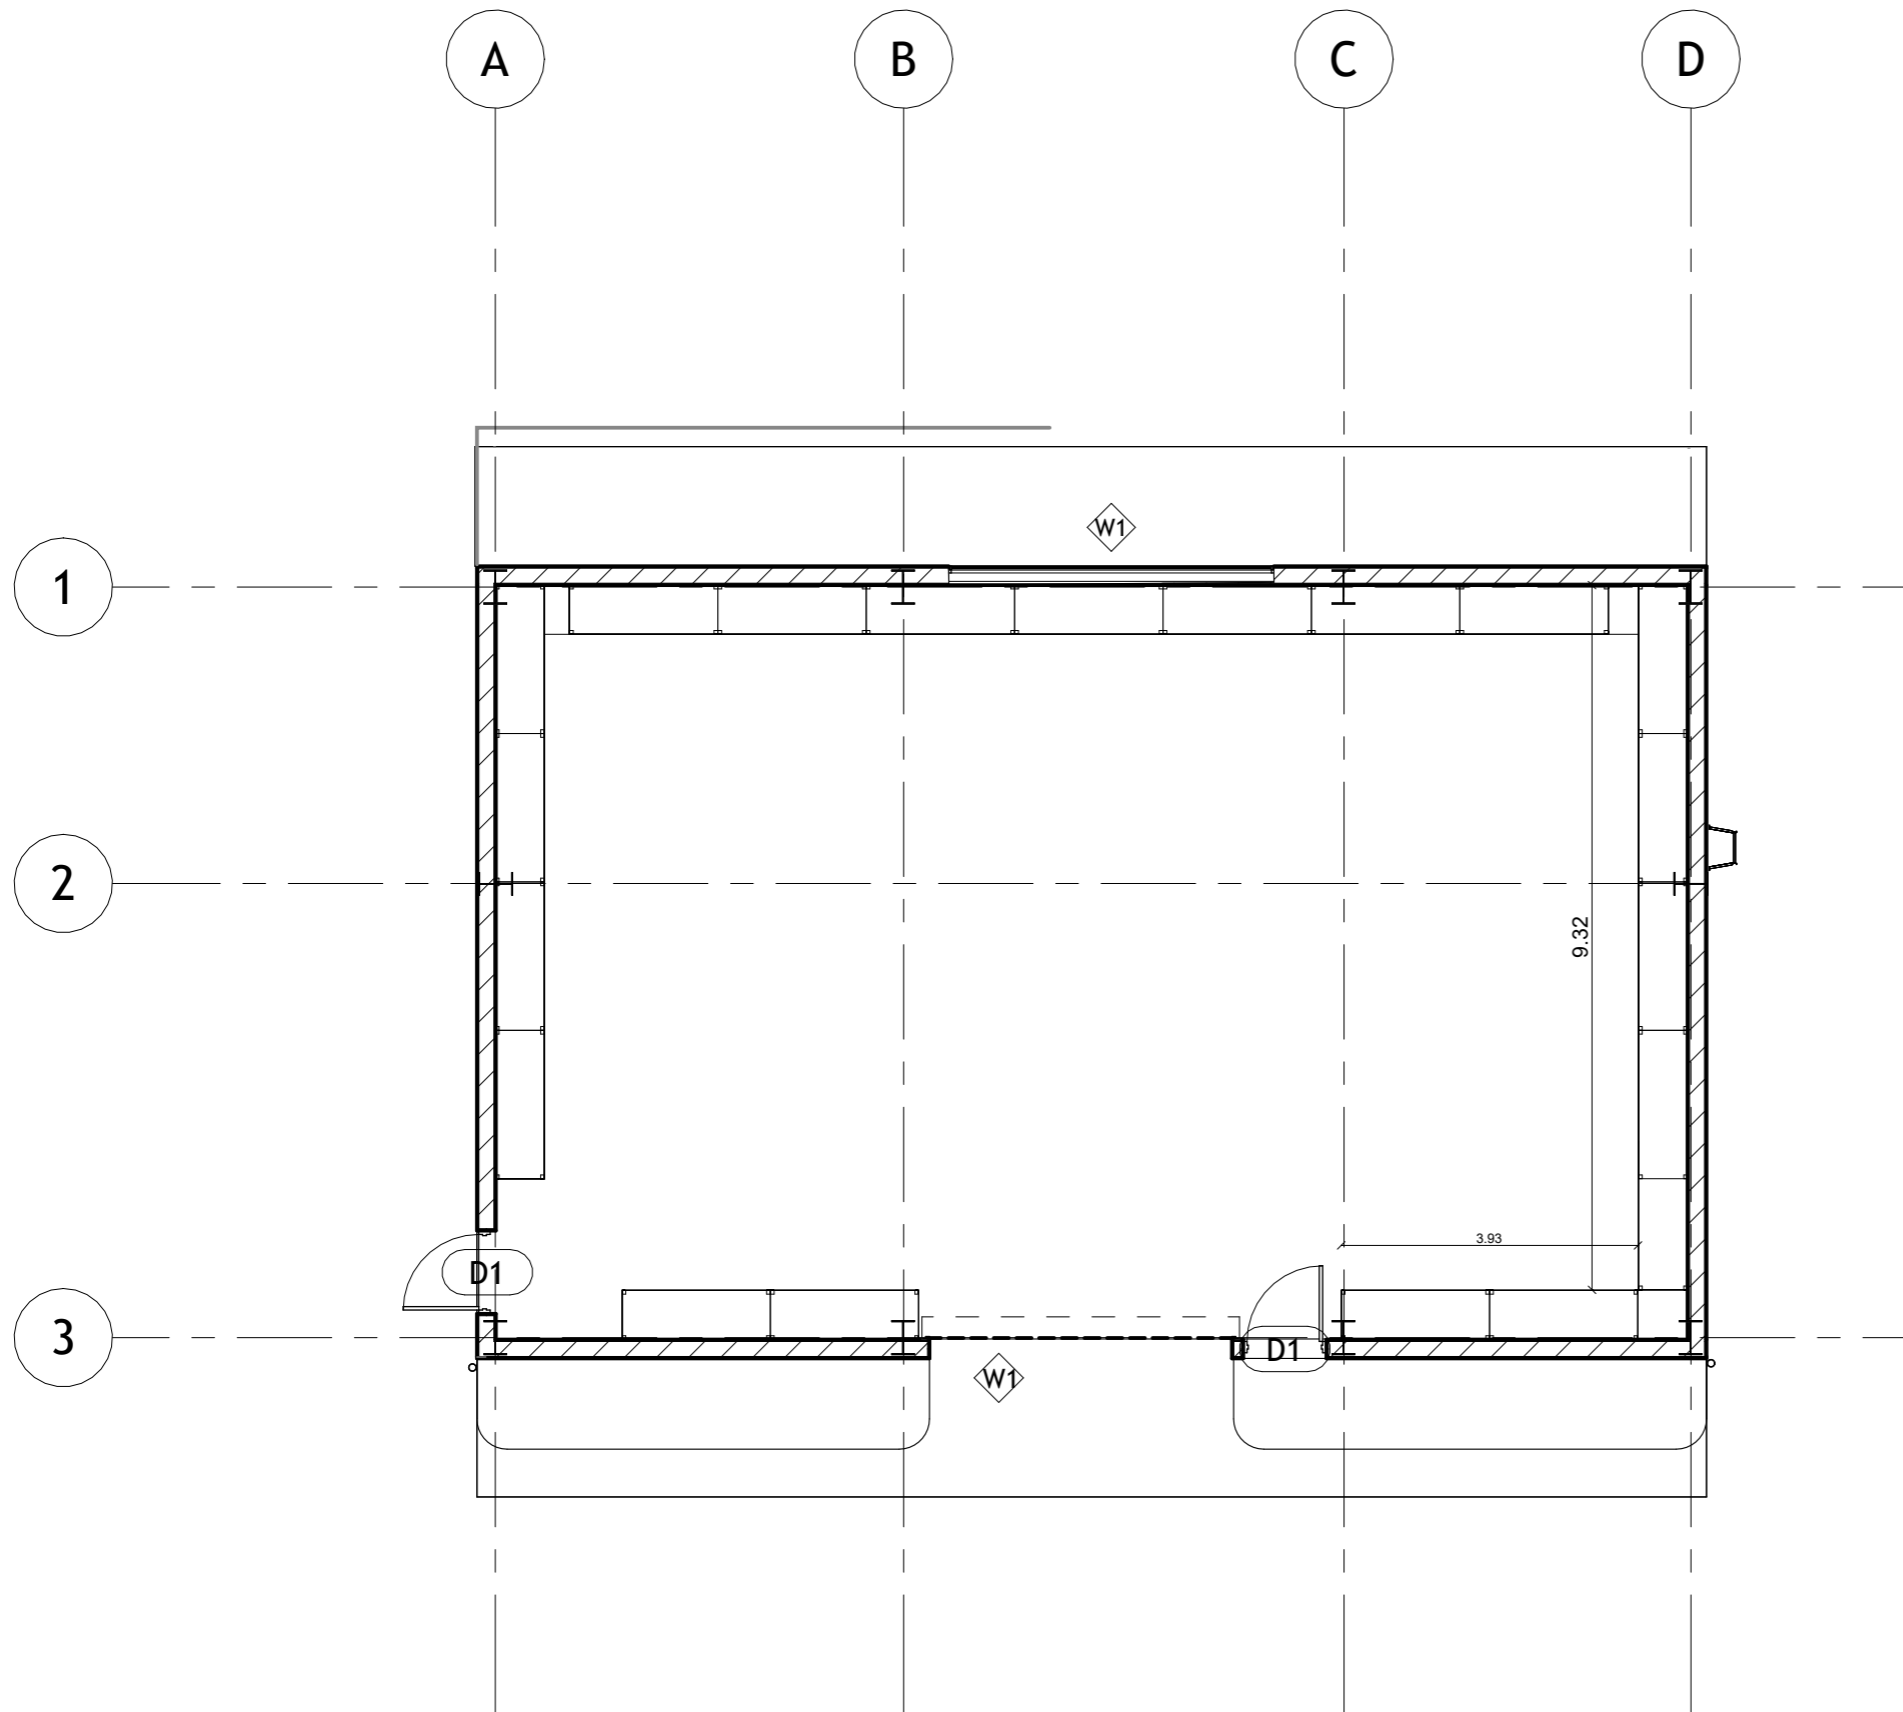

Plot No.	Basin No.	Basin name	The village
268	9	ALASHAAL	LOB

Client Name
ALMODON INDUSTRIAL COMPANY
Project Name

GROUND FLOOR FURNITURE

Project number 306

Date Issue Date

Design by : Arch.Jana 218186

Checked by : Arch.Suhail 200097

A105

Scale 1:100



VANZUELLA

Vanzulla Company For Consulting
Engineering Designs
(2824)

Tel- 0789695422

Door Schedule .			
Type Mark	Height	Width	Count
D1	2.00	1.00	2

Window Schedule .			
Type Mark	Height	Width	Count
W1	1.00	4.30	2

Plot No.	Basin No.	Basin name	The village
268	9	ALASHAAL	LOB

Client Name
ALMODON INDUSTRIAL COMPANY
Project Name

TABLE OF DOORS & WINDOWS

Project number 306

Date Issue Date

Design by : Arch.Jana 218186

Checked by : Arch.Suhail 200097

A106



Scale 1:100



VANZUELLA

Vanzulla Company For Consulting
Engineering Designs
(2824)

Tel- 0789695422

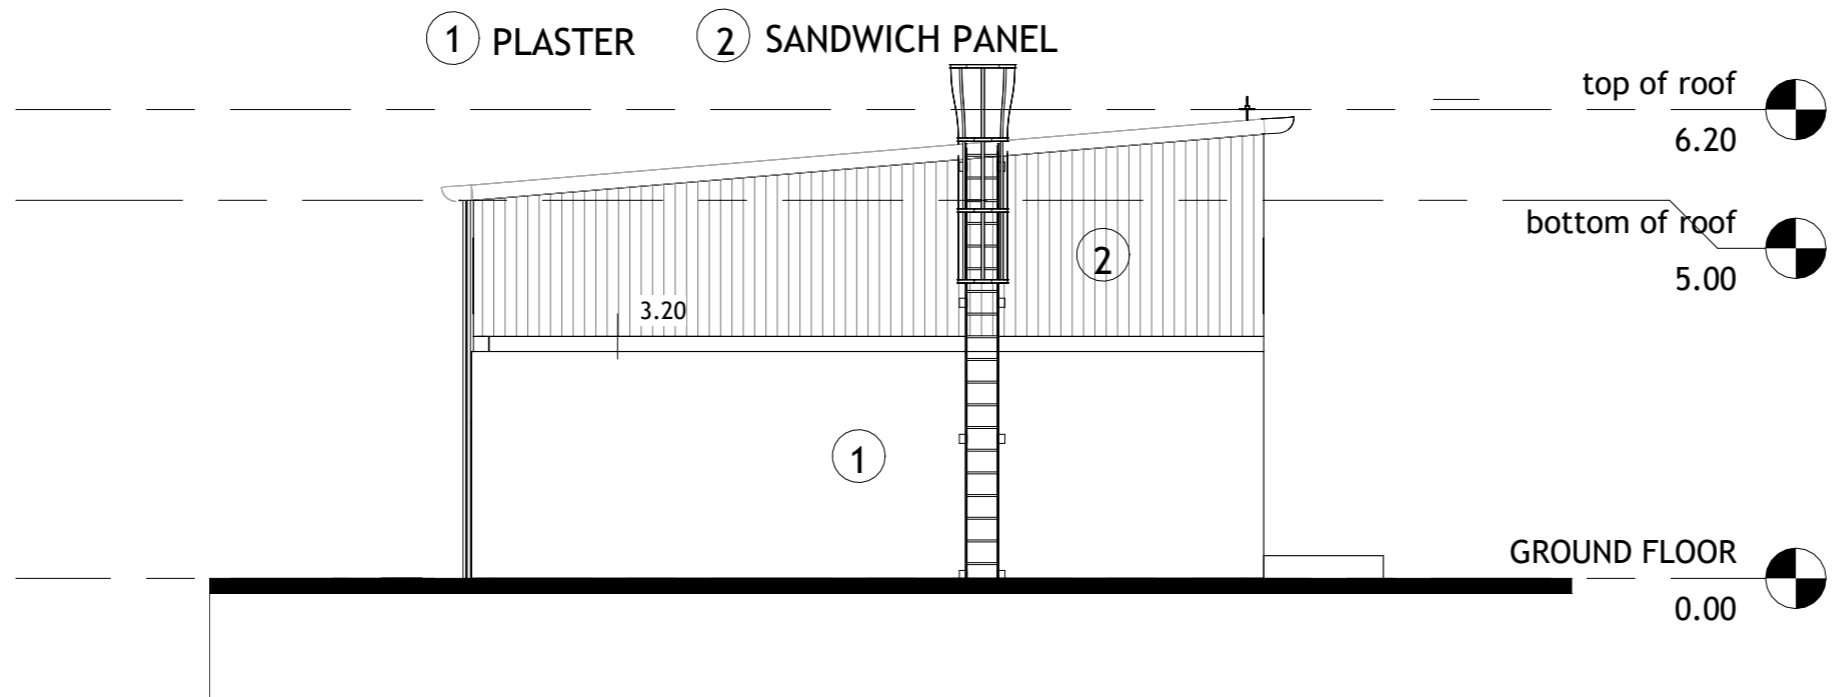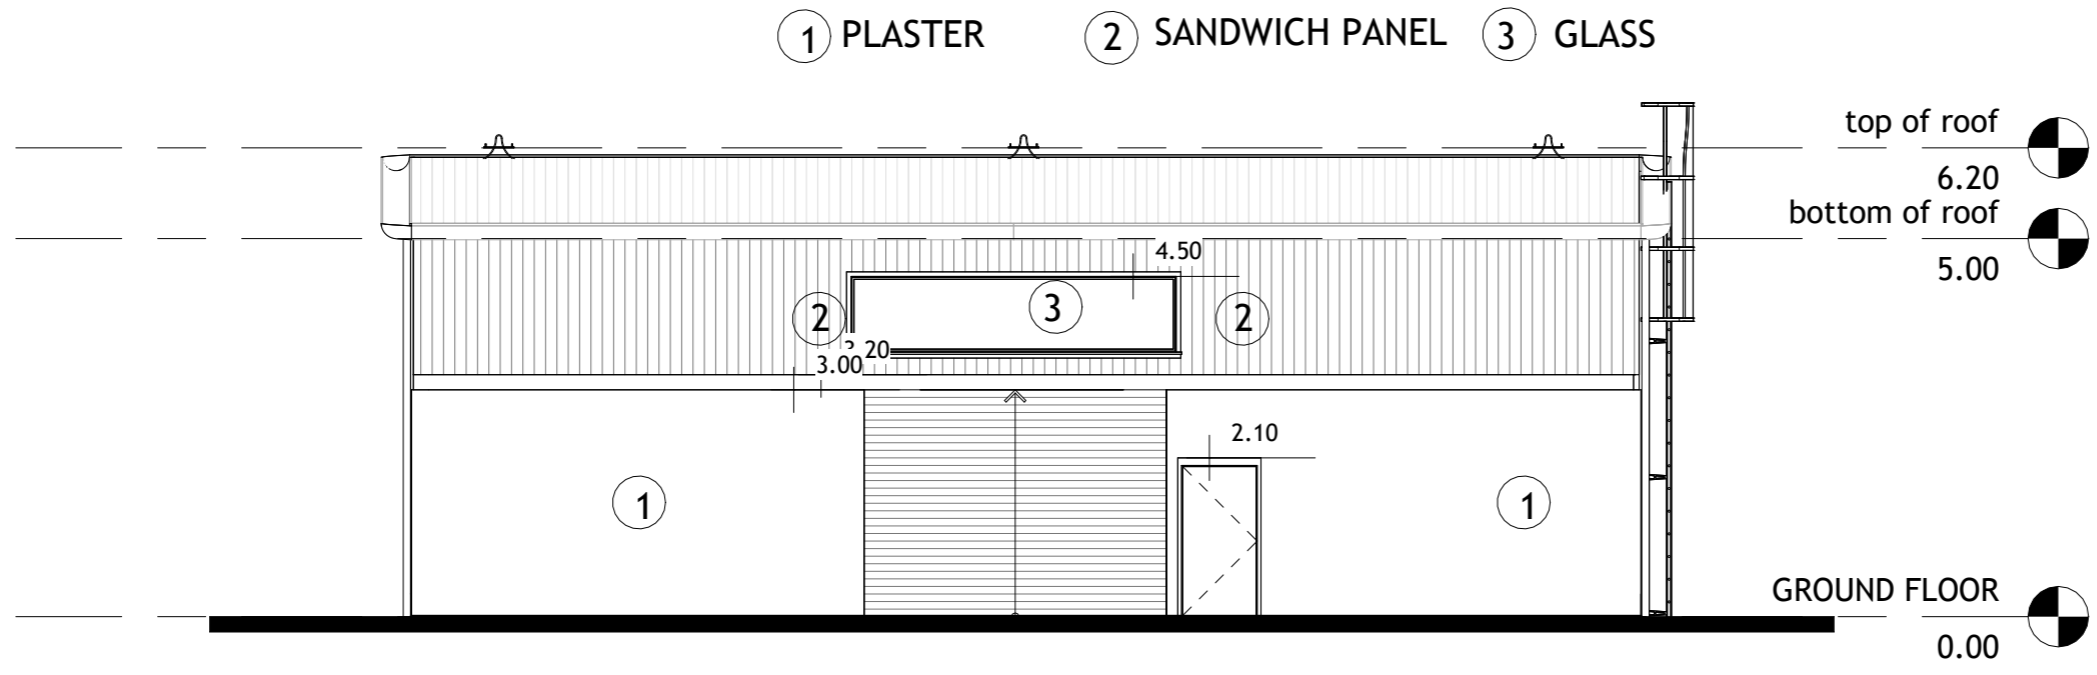

Plot No.	Basin No.	Basin name	The village

--	--	--	--

Client Name
الشركة العامة الاردنية للصوامع والتموين المساهمة
العامة المحدودة.
Project Name

ELEVATIONS

Project number 306

Date Issue Date

Design by : Arch. Shahed 218190

Checked by : Arch. Suhail 200097

A107



Scale 1:100



VANZUELLA

Vanzulla Company For Consulting
Engineering Designs
(2824)

Tel- 0789695422

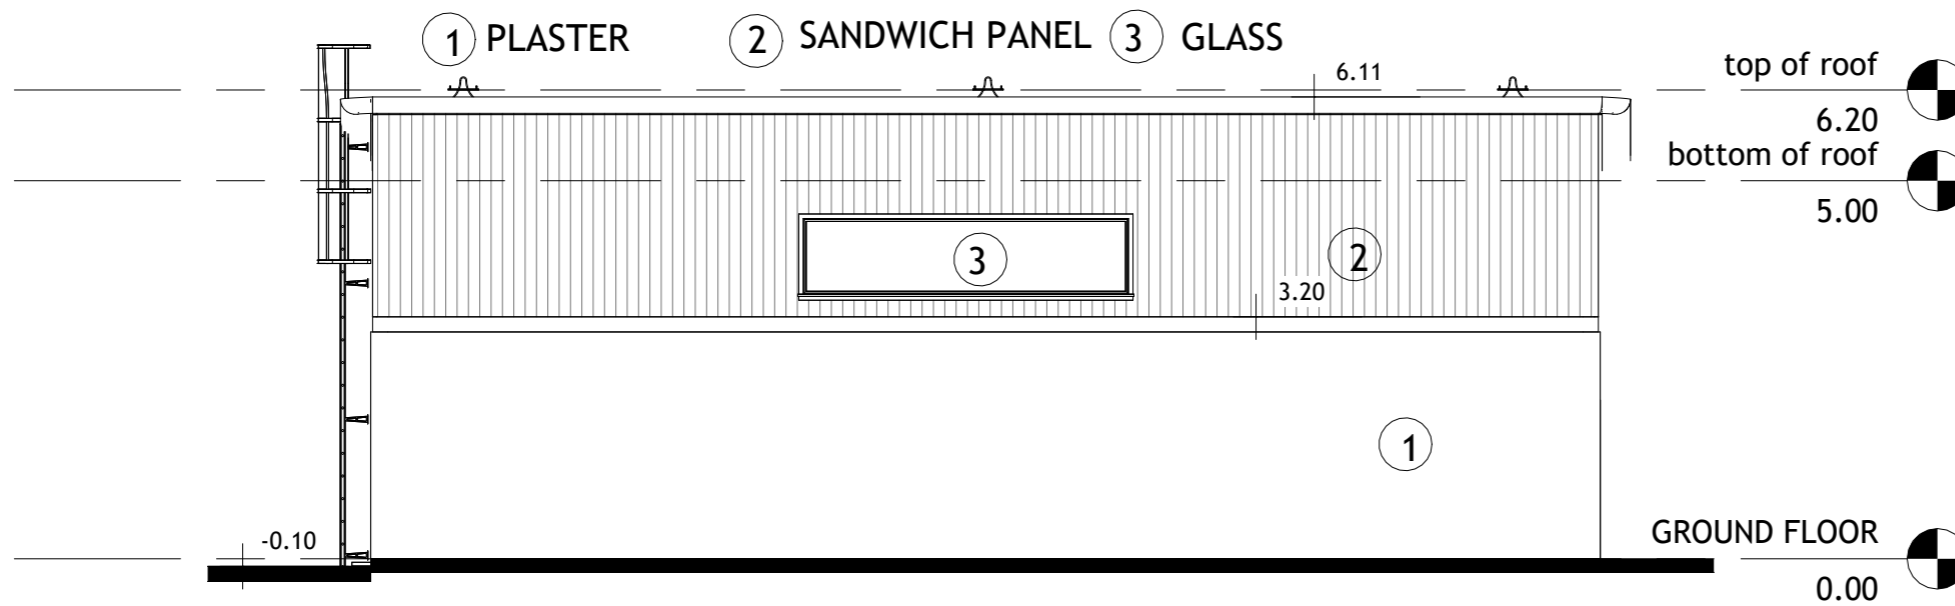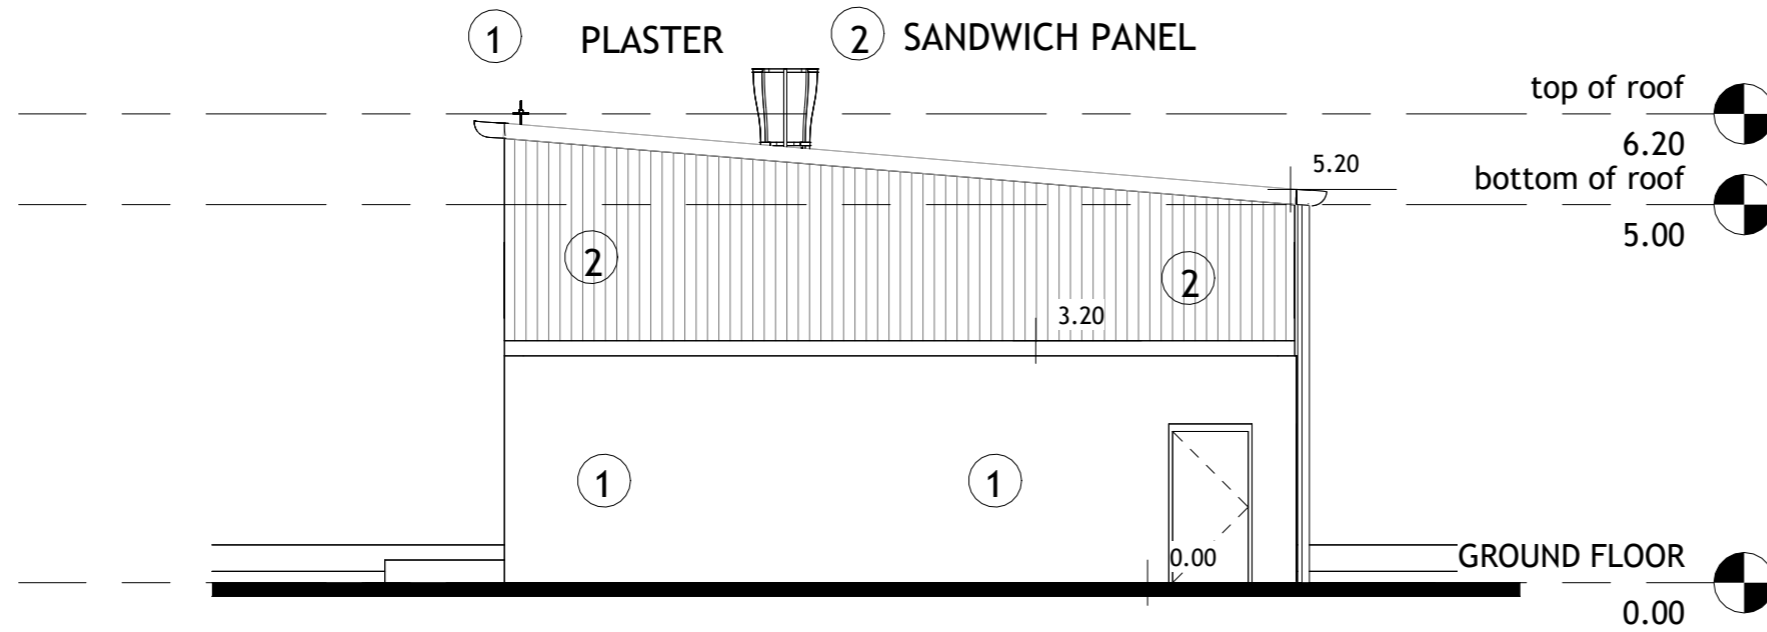

Plot No. Basin No. Basin name The village

--	--	--	--

Client Name
 الشركة العامة الاردنية للصوامع والتموين المساهمة
 العامة المحدودة.
 Project Name

ELEVATIONS

Project number 306

Date Issue Date


Design by : Arch. Shahed 218190

Checked by : Arch. Suhail 200097

A107.5


Scale 1:100

SECTION A-A

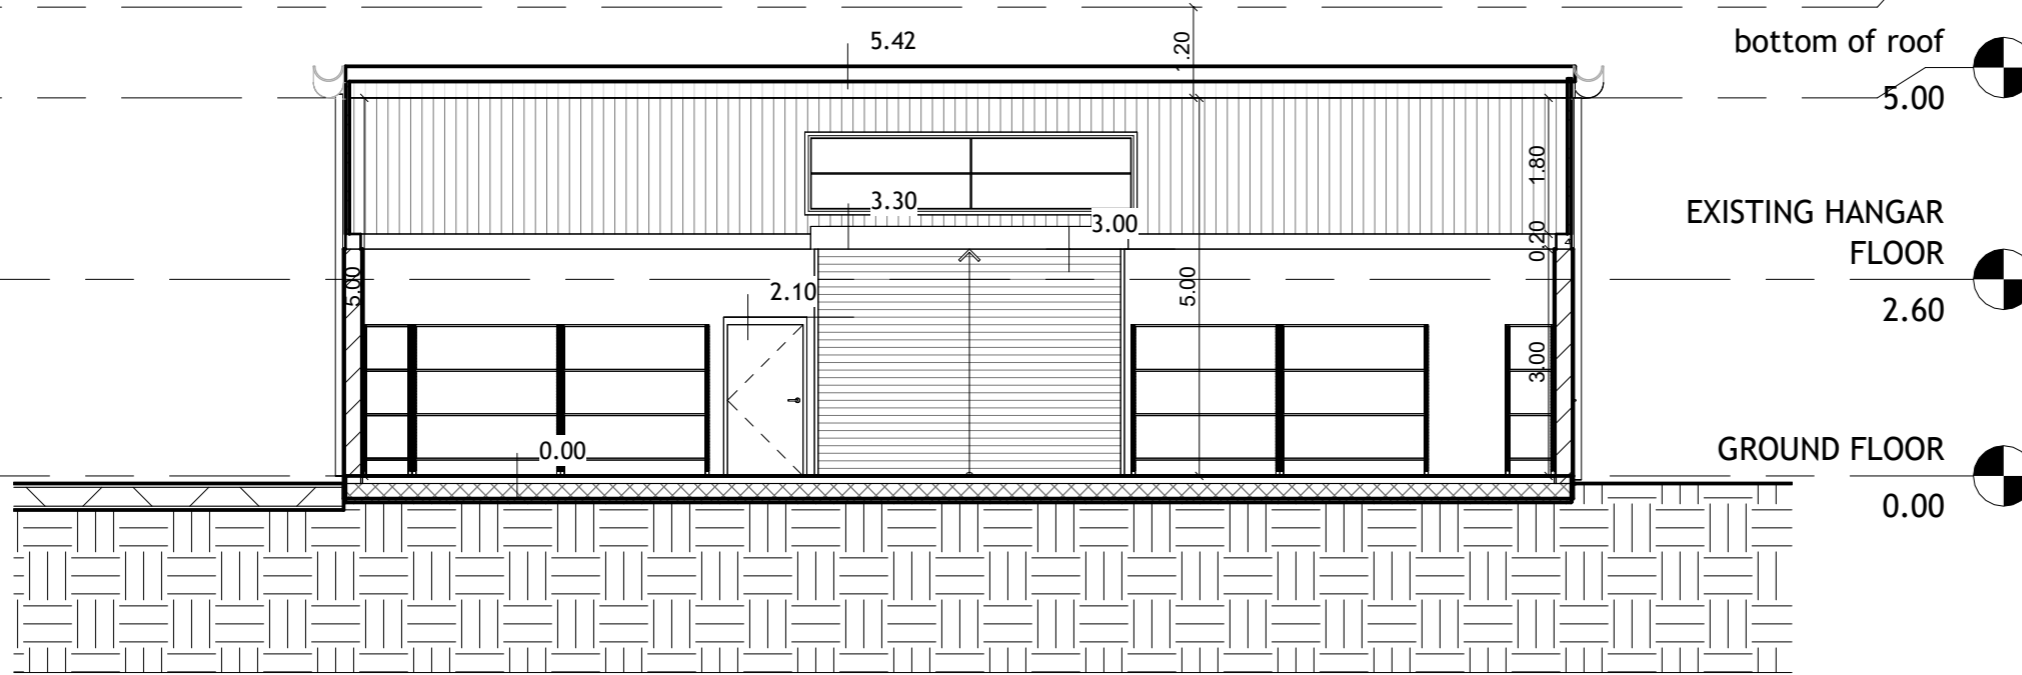


- top of roof 6.20
- bottom of roof 5.00
- EXISTING HANGAR FLOOR 2.60
- GROUND FLOOR 0.00

SECTION B-B

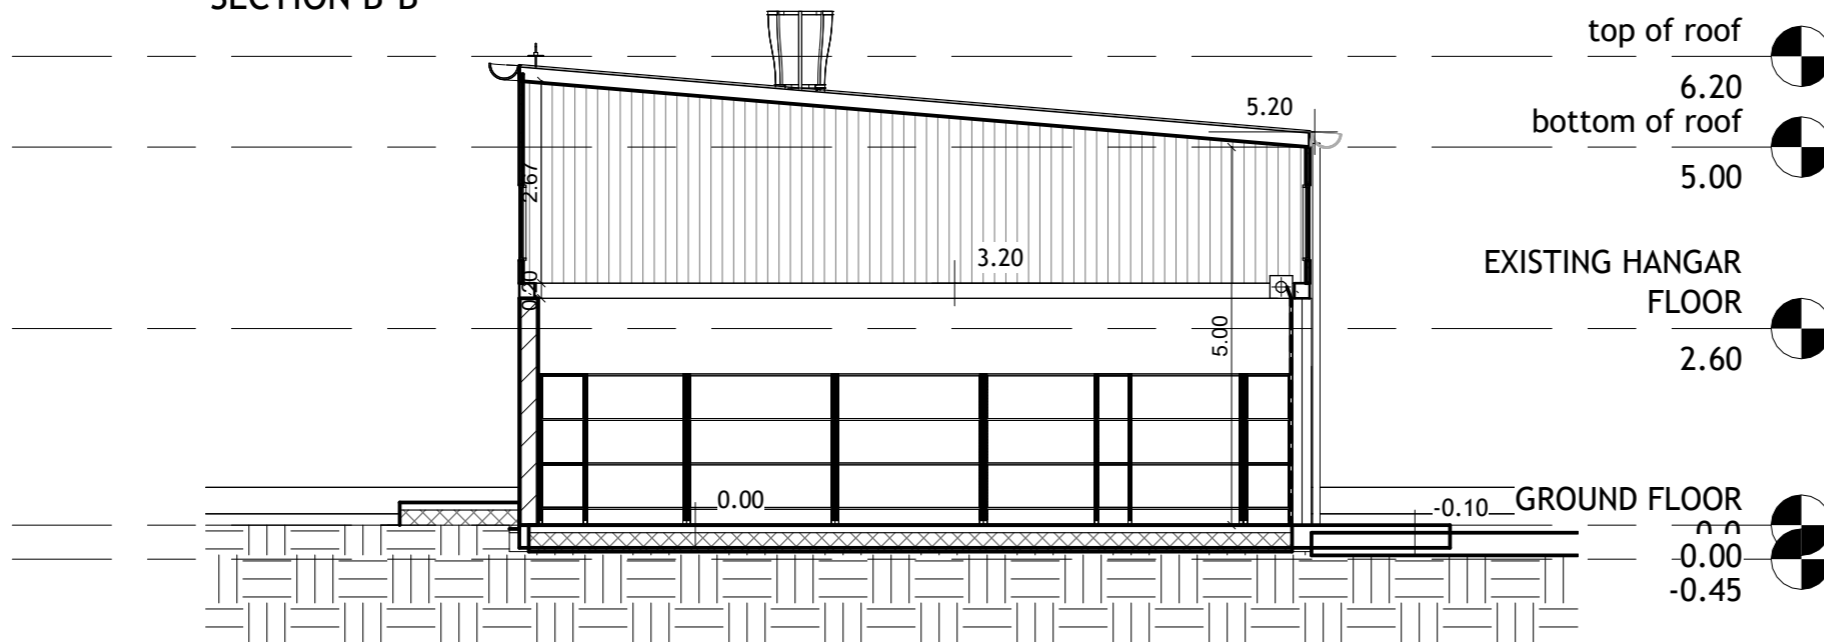

- top of roof 6.20
- bottom of roof 5.00
- EXISTING HANGAR FLOOR 2.60
- GROUND FLOOR 0.00
- 0.10
- 0.45

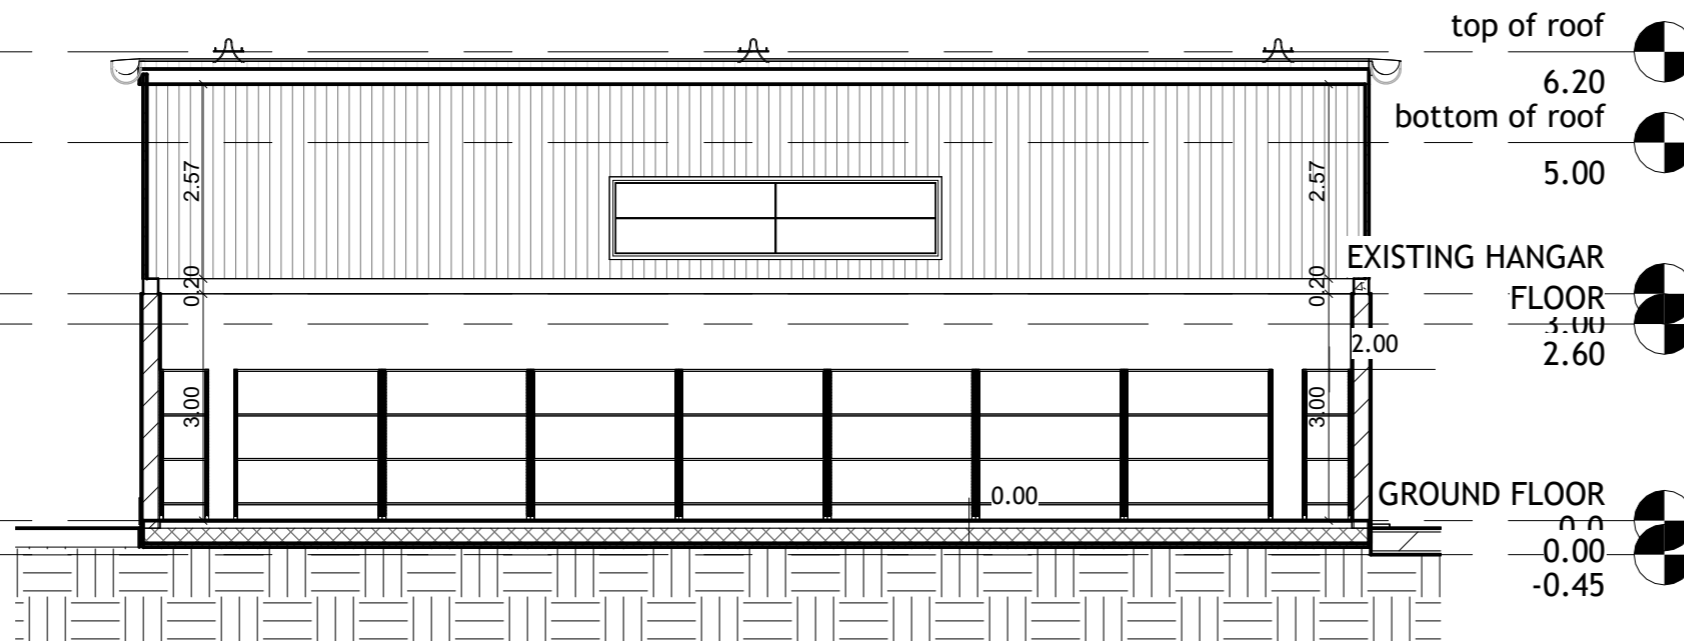

- top of roof 6.20
- bottom of roof 5.00
- EXISTING HANGAR FLOOR 2.60
- GROUND FLOOR 0.00
- 0.45



VANZUELLA

Vanzulla Company For Consulting
Engineering Designs
(2824)
Tel- 0789695422

Plot No. Basin No. Basin name The village

Client Name
الشركة العامة الاردنية للصوامع والتموين المساهمة
العامة المحدودة.
Project Name

SECTIONS

Project number 306

Date Issue Date

Design by : Arch. Shahed 218190

Checked by : Arch. Suhail 200097

A108




Scale 1:100



VANZUELLA

Vanzulla Company For Consulting
Engineering Designs
(2824)

 Tel- 0789695422

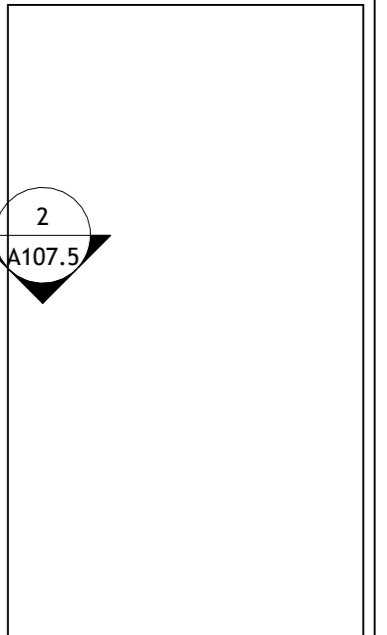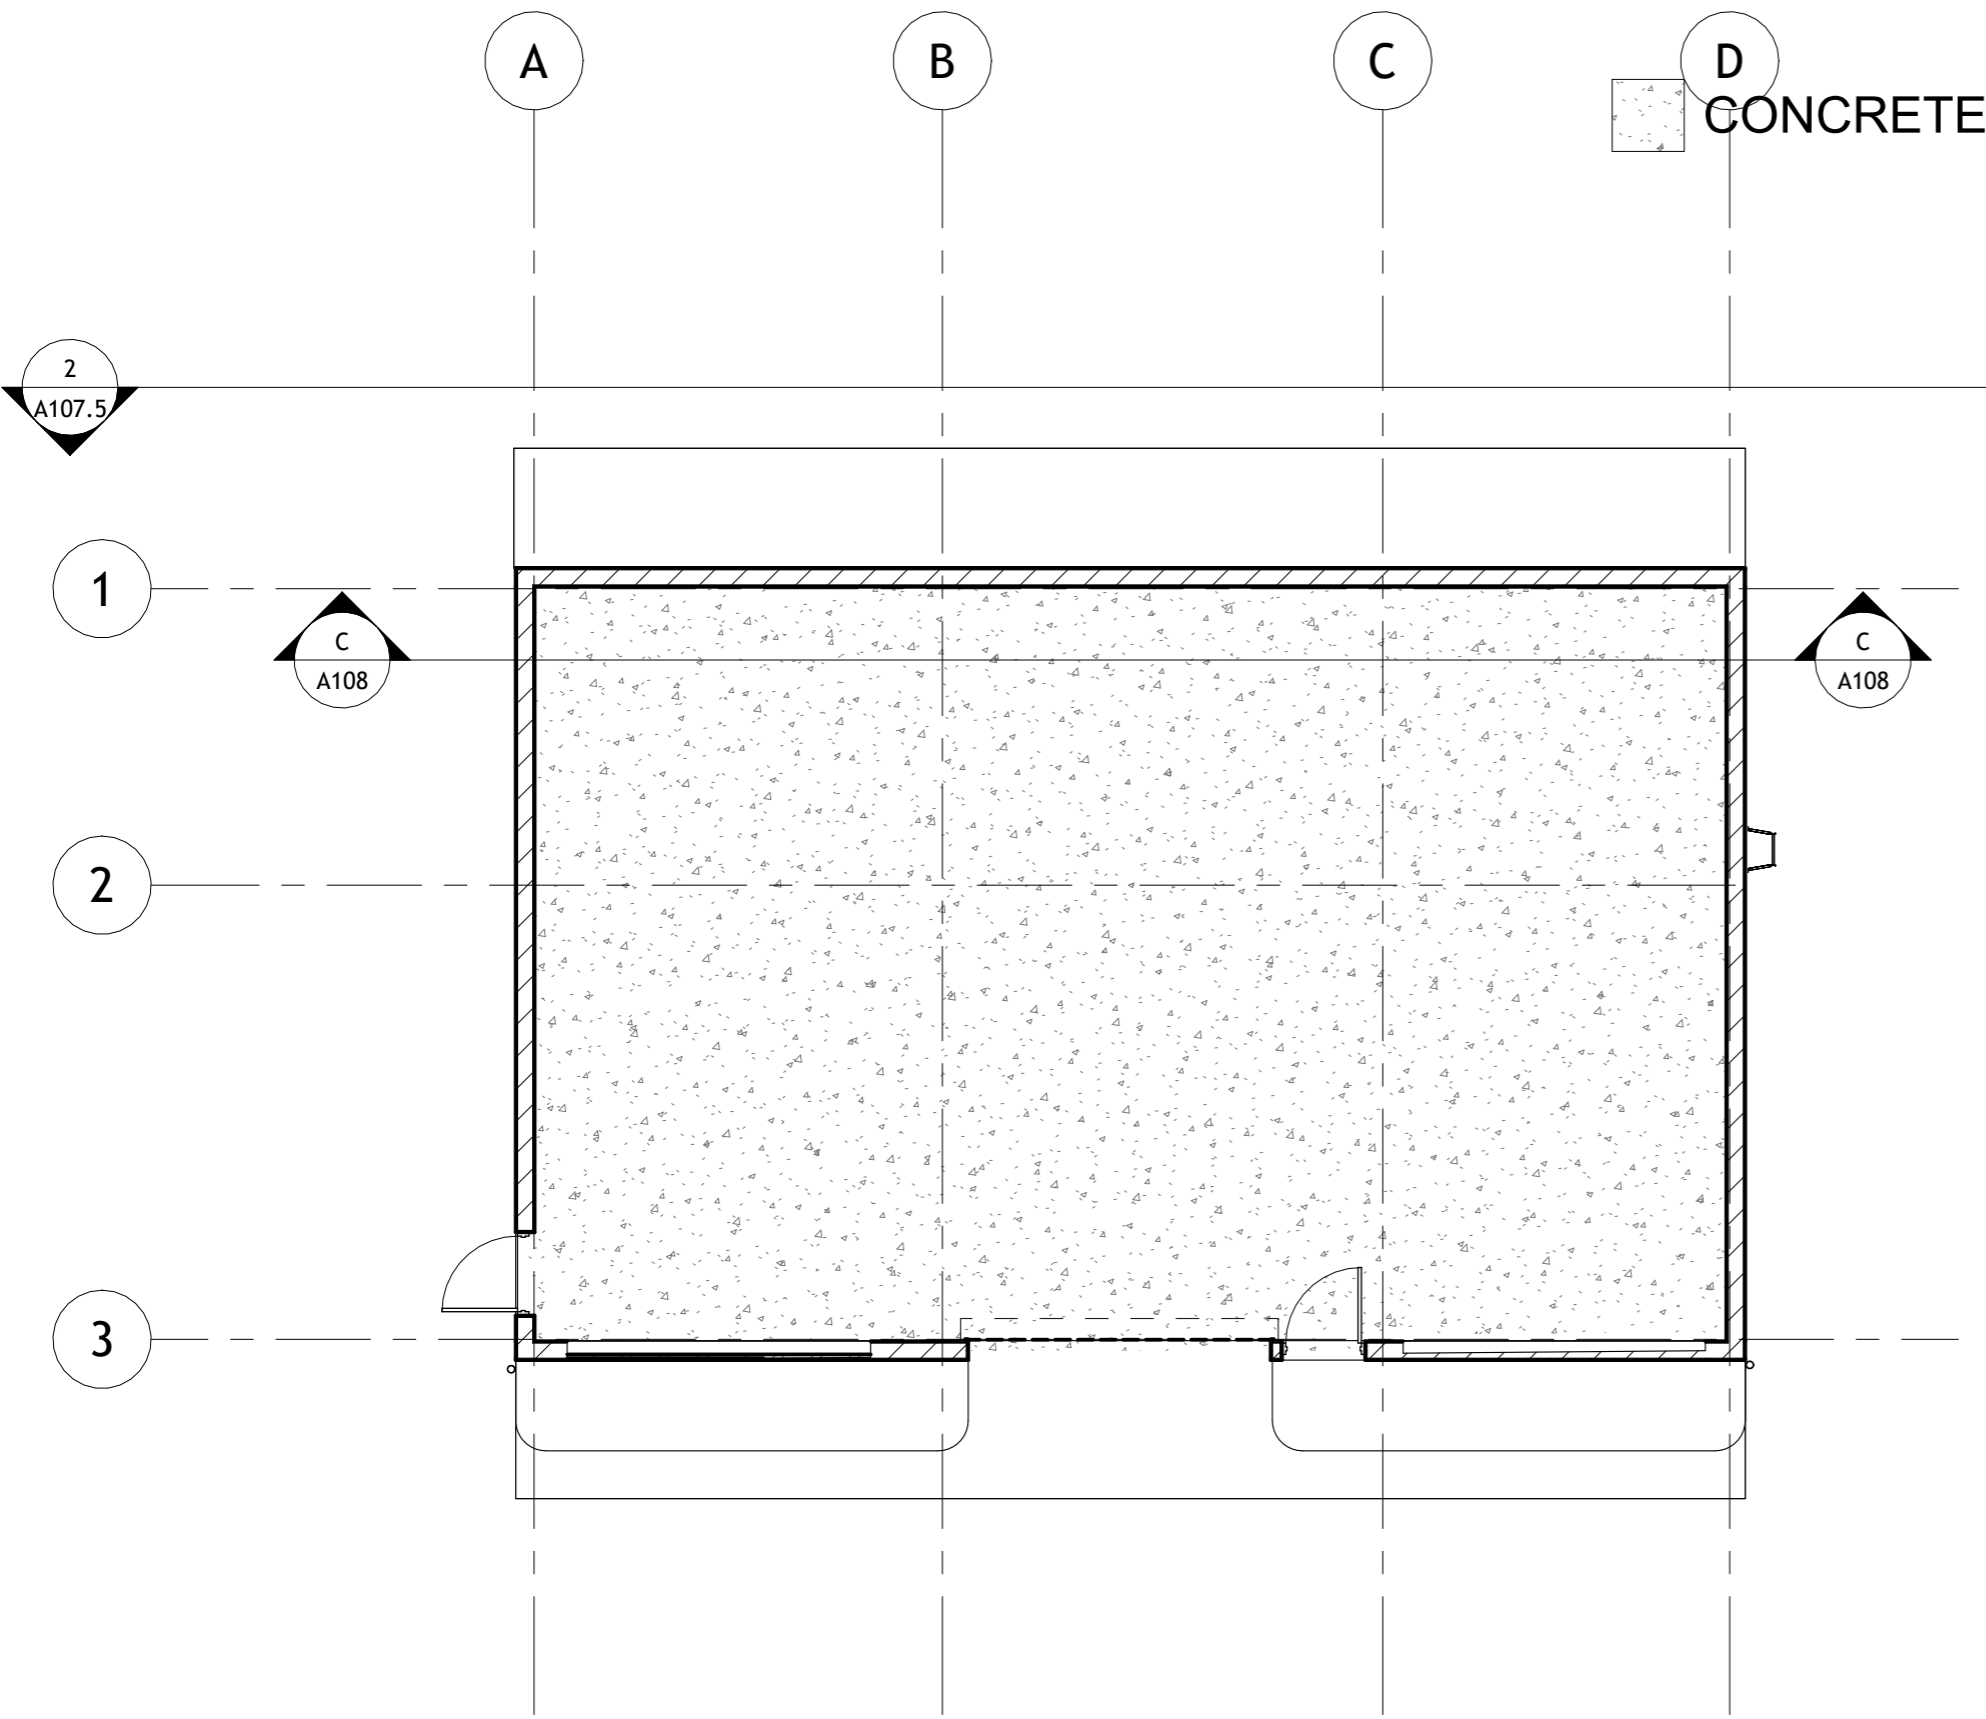

Plot No.	Basin No.	Basin name	The village
268	9	ALASHAAL	LOB

Client Name
ALMODON INDUSTRIAL COMPANY

Project Name

GROUND FLOOR FINISH

Project number 306

Date Issue Date


Design by : Arch.Jana 218186

Checked by : Arch.Suhail 200097


A109

Scale 1:100

DIXON SHELVES DETAIL

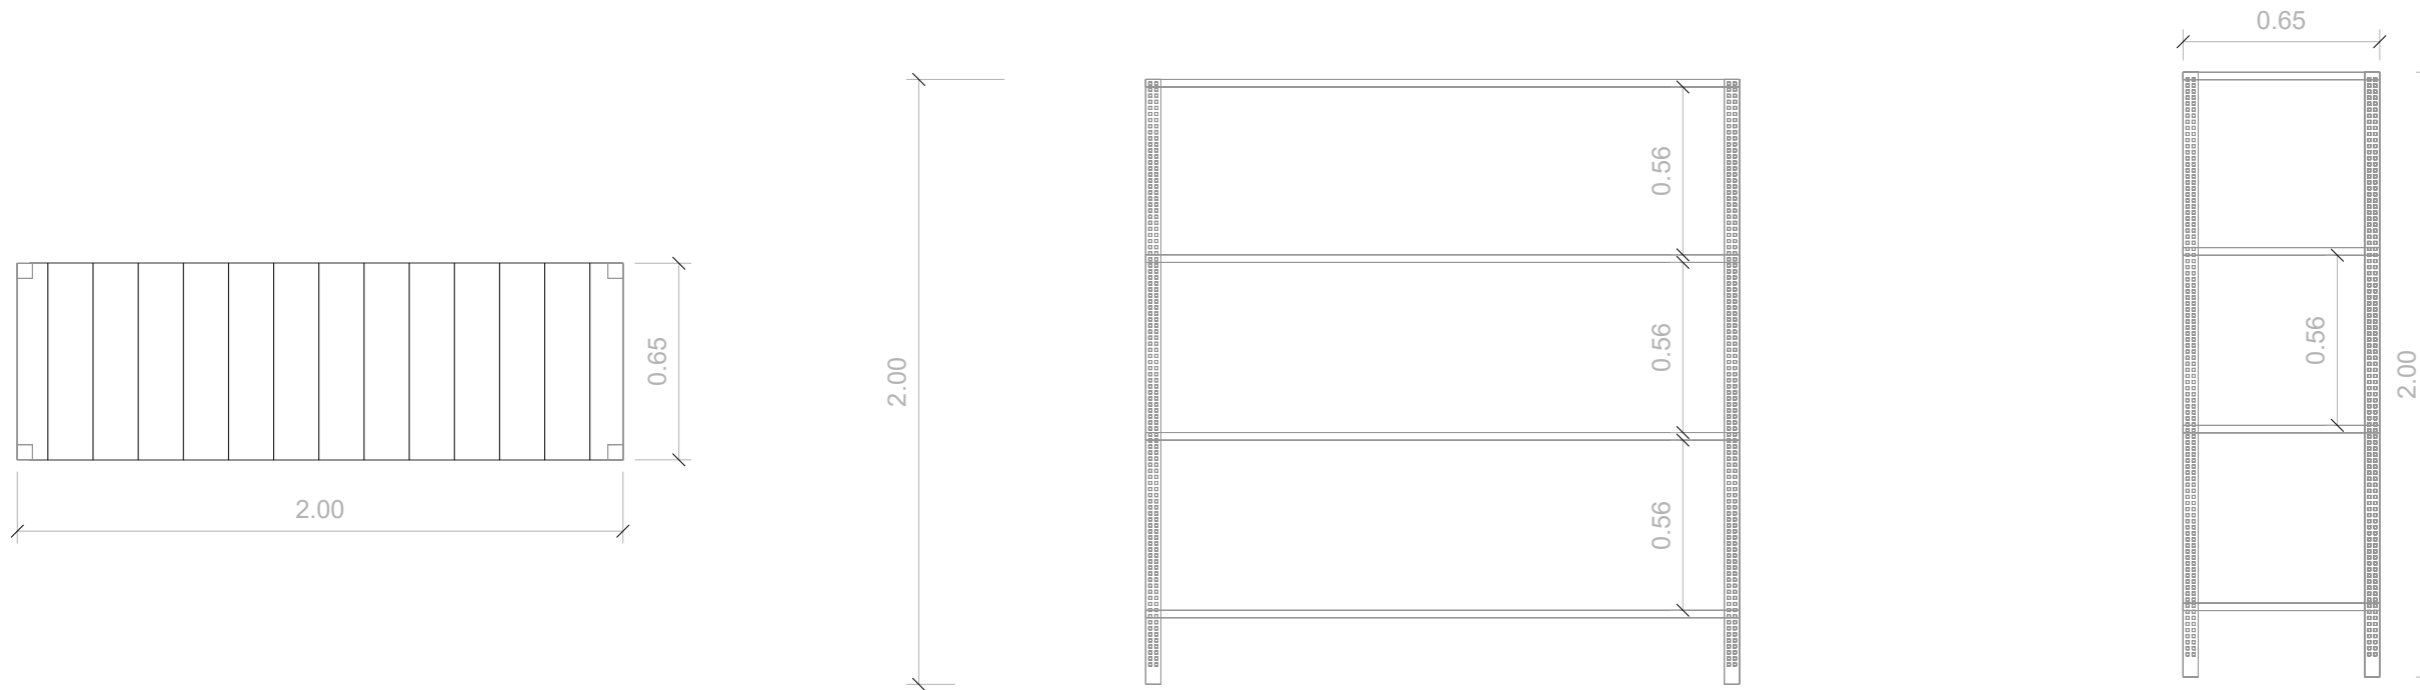

DRAIN LINE COVER DETAIL

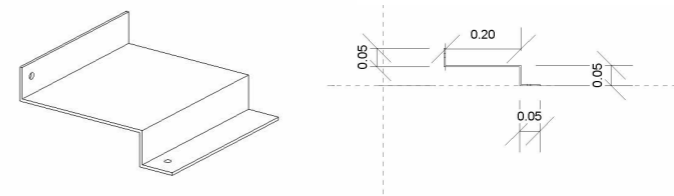

VANZUELLA

Vanzulla Company For Consulting
Engineering Designs
(2824)

Tel- 0789695422

Plot No.	Basin No.	Basin name	The village

Client Name
الشركة العامة الاردنية للصوامع والتموين المساهمة
العامة المحدودة.

Project Name

DETAILS 1

Project number 306

Date Issue Date

Design by : Arch. Shahed 218190

Checked by : Arch. Suhail 200097

A110


Scale 1 25



VANZUELLA

Vanzulla Company For Consulting
Engineering Designs
(2824)
Tel- 0789695422

WINDOWS SCHEDULE

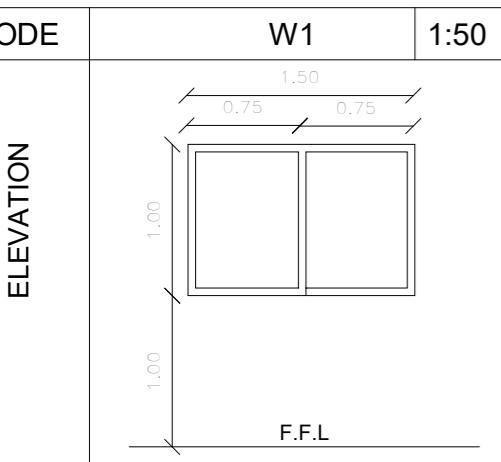

CODE W1 1:50
SIZE 1500*1750


MATERIAL POWDER COATED ALUMINUM DOOR COLOR TO CLIENT APPROVAL

HARDWARE SET
6No. STAINLESS STEEL HINGES
4No. STAINLESS STEEL LEVER HANDLES.
1No. LOCKSET WITH DEAD BOLT AND LATCH.
1No. CYLINDER LOCK WITH 3 KEYS

GLAZING OR VIEW PANEL 24mm DOUBLE GLAZED
OPENING SLIDING AND FIXED

NOTES STORE DOOR

WINDOWS SHADUAL

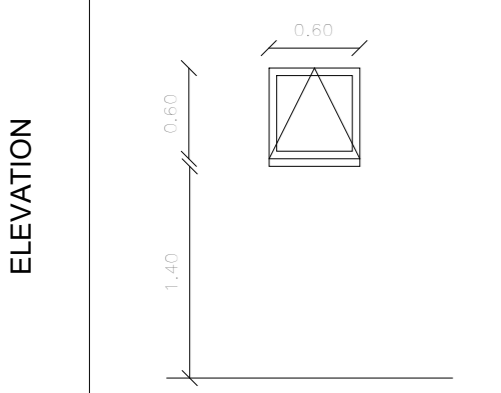

CODE W2 1:50
SIZE 600*600


MATERIAL POWDER COATED ALUMINUM DOOR COLOR TO CLIENT APPROVAL

HARDWARE SET
2No. STAINLESS STEEL HINGES
1No. LOCKSET
1No. GRAB HOCK

GLAZING OR VIEW PANEL 24mm DOUBLE GLAZED ITCHED
OPENING HINGED

NOTES USED FOR OUTSIDE DOOR

DOOR SCHEDULE

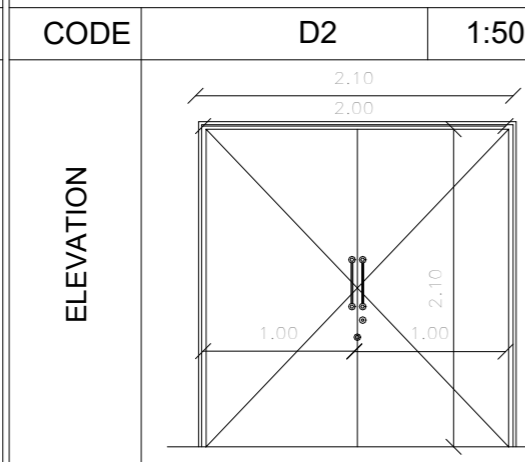


CODE D2 1:50
SIZE 2000*2100

MATERIAL FRAME POWDER COATED ALUMINUM DOOR COLOR TO CLIENT APPROVAL
LEAF POWDER COATED FLUSH STEEL DOOR (1h FIRE-RATED) COLOR (DARK BLUE)TO CLIENT APPROVAL

HARDWARE SET
6No. STAINLESS STEEL HINGES
4No. STAINLESS STEEL LEVER HANDLES.
1No. LOCKSET WITH DEAD BOLT AND LATCH.
1No. CYLINDER LOCK WITH 3 KEYS

GLAZING OR VIEW PANEL 10mm THICK TEMPERED GLASS
OPENING HINGED

NOTES STORE DOOR

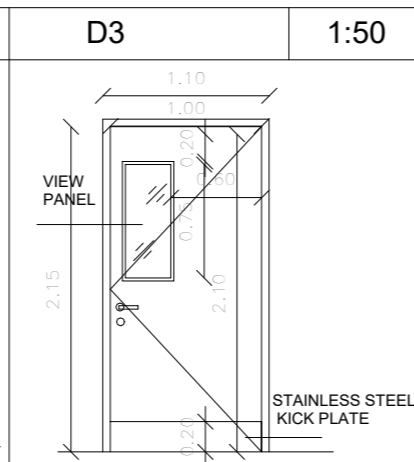


CODE D3 1:50
SIZE 1000*2100

MATERIAL FRAME POWDER COATED ALUMINUM DOOR COLOR TO CLIENT APPROVAL
LEAF WOOD WITH PLASTIC LAMINATE SURFACE COLOR (DARK BLUE) TO CLIENT APPROVAL WITH VIEW PANEL

HARDWARE SET
3No. STAINLESS STEEL HINGES WITH BALL BEARING
2No. STAINLESS STEEL LEVER HANDLES.
1No. LEVER LOCKSET WITH DEAD BOLT AND LATCH
1No. CYLINDER LOCK WITH 3 KEYS

GLAZING OR VIEW PANEL 10mm THICK TEMPERED GLASS
OPENING HINGED

NOTES STORE DOOR

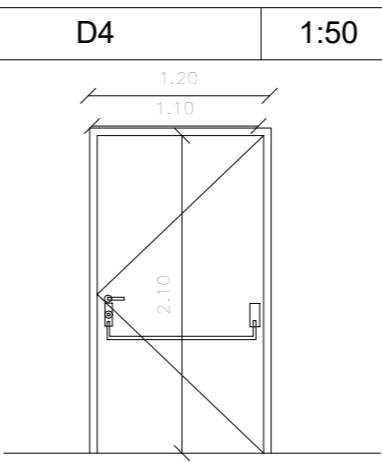


CODE D4 1:50
SIZE 1100*2100

MATERIAL FRAME POWDER COATED ALUMINUM DOOR COLOR TO CLIENT APPROVAL
LEAF POWDER COATED FLUSH STEEL DOOR COLOR TO CLIENT APPROVAL

HARDWARE SET
3No. STAINLESS STEEL HINGES WITH BALL BEARING
1No. STAINLESS STEEL LEVER HANDLES.
1No. LEVER LOCKSET WITH DEAD BOLT AND LATCH.
1No. PANIC HANDLE, PROVIDED TO OPENING SIDE AND EQUIPPED WITH LOCKING DEVICE FROM OUTSIDE RELEASED AUTOMATICALLY BY THE PANIC HANDLE.

GLAZING OR VIEW PANEL 10mm THICK TEMPERED GLASS
OPENING HINGED

NOTES USED FOR EMERGENCY EXITS

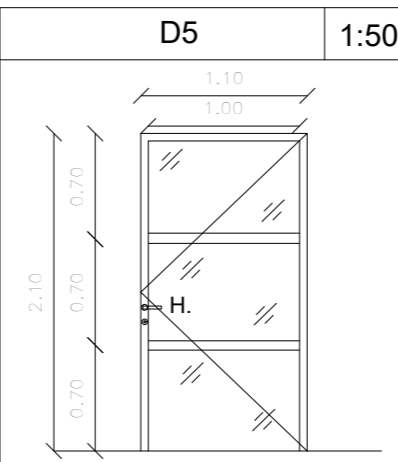


CODE D5 1:50
SIZE 1000*2100

MATERIAL FRAME POWDER COATED ALUMINUM DOOR COLOR TO CLIENT APPROVAL
LEAF POWDER COATED ALUMINUM DOOR WITH GLAZING COLOR TO CLIENT APPROVAL

HARDWARE SET
6No. STAINLESS STEEL HINGES
4No. STAINLESS STEEL LEVER HANDLES.
1No. LOCKSET WITH DEAD BOLT AND LATCH.
1No. CYLINDER LOCK WITH 3 KEYS

GLAZING OR VIEW PANEL 24mm DOUBLE GLAZED
OPENING HINGED

NOTES HANGAR OFFICE

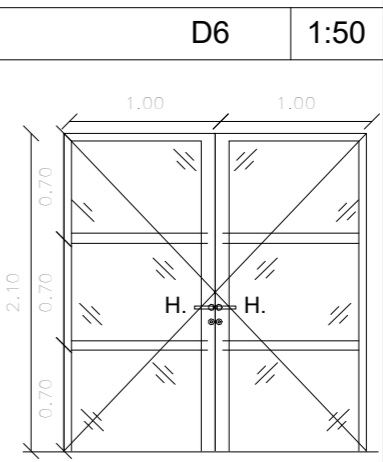


CODE D6 1:50
SIZE 1000*2100

MATERIAL FRAME POWDER COATED ALUMINUM DOOR COLOR TO CLIENT APPROVAL
LEAF POWDER COATED ALUMINUM DOOR WITH GLAZING COLOR TO CLIENT APPROVAL


HARDWARE SET
6No. STAINLESS STEEL HINGES
4No. STAINLESS STEEL LEVER HANDLES.
1No. LOCKSET WITH DEAD BOLT AND LATCH.
1No. CYLINDER LOCK WITH 3 KEYS

GLAZING OR VIEW PANEL 24mm DOUBLE GLAZED
OPENING HINGED

NOTES NEEDLE DIRECTOR

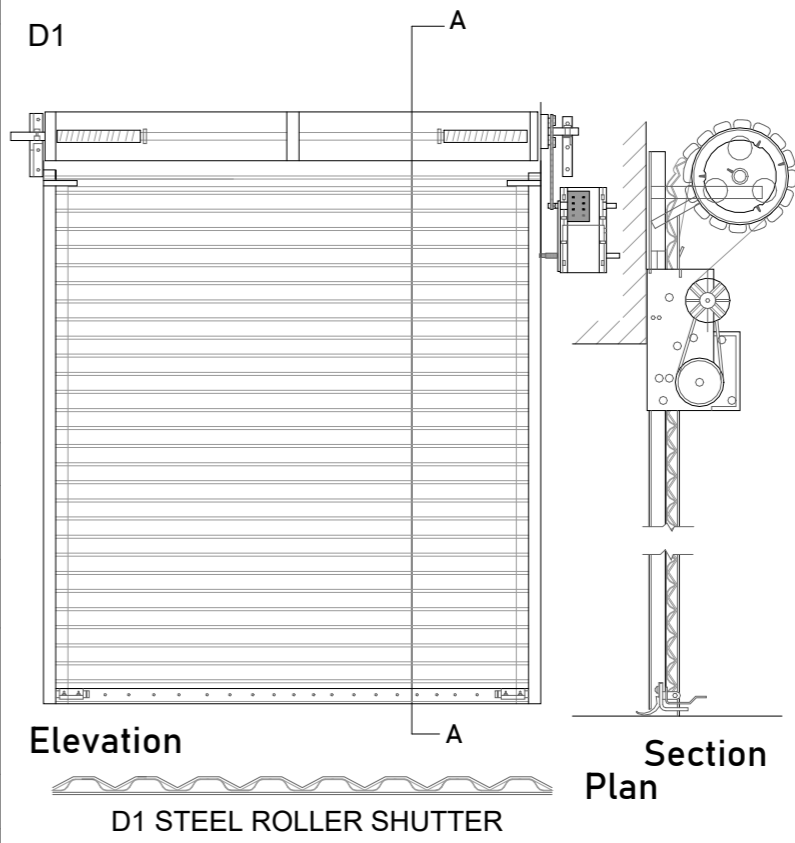

Elevation Section Plan
D1 STEEL ROLLER SHUTTER

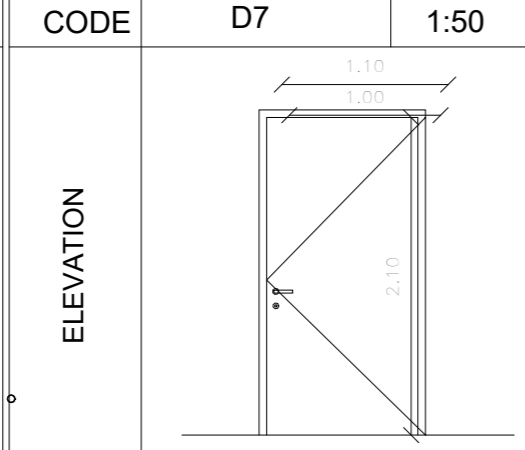


CODE D7 1:50
SIZE 2000*2100

MATERIAL FRAME POWDER COATED FLUSH STEEL FRAME COLOR TO CLIENT APPROVAL
LEAF POWDER COATED FLUSH STEEL DOOR (1h FIRE-RATED) COLOR TO CLIENT APPROVAL

HARDWARE SET
3No. STAINLESS STEEL HINGES WITH BALL BEARING
2No. STAINLESS STEEL LEVER HANDLES.
1No. LEVER LOCKSET WITH DEAD BOLT AND LATCH.
1No. CYLINDER LOCK WITH 3 KEYS FOR HC TOILETS:
1No. TURNING KNOB LOCK FROM INSIDE, (UNLOCKING FROM OUTSIDE IS POSSIBLE)

GLAZING OR VIEW PANEL 10mm THICK TEMPERED GLASS
OPENING HINGED

NOTES USED FOR OUTSIDE DOOR

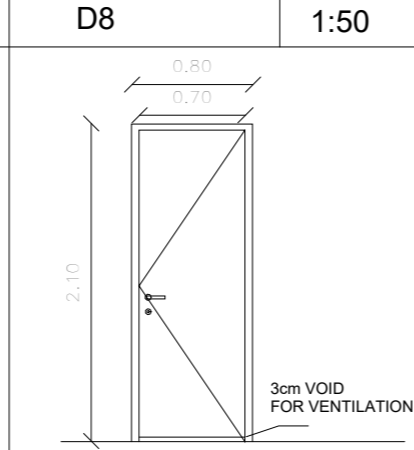


CODE D8 1:50
SIZE 800*2100

MATERIAL FRAME POWDER COATED FLUSH STEEL FRAME COLOR (GRAY) TO CLIENT APPROVAL
LEAF WOOD WITH PLASTIC LAMINATE SURFACE COLOR TO CLIENT APPROVAL

HARDWARE SET
3No. STAINLESS STEEL HINGES WITH BALL BEARING
2No. STAINLESS STEEL LEVER HANDLES.
1No. LEVER LOCKSET WITH DEAD BOLT AND LATCH.
1No. TURNING KNOB LOCK FROM INSIDE, (UNLOCKING FROM OUTSIDE IS POSSIBLE)

GLAZING OR VIEW PANEL 10mm THICK TEMPERED GLASS
OPENING HINGED

NOTES USED FOR TOILET

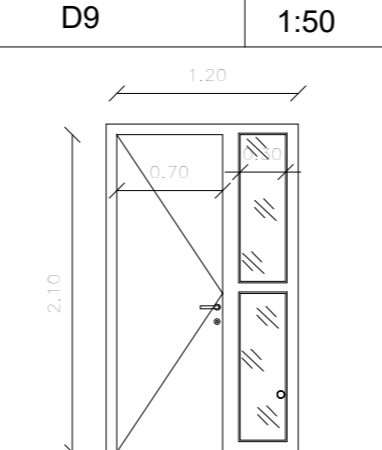

CODE D9 1:50
SIZE 1200*2100

MATERIAL FRAME POWDER COATED FLUSH STEEL FRAME COLOR (GRAY) TO CLIENT APPROVAL
LEAF POWDER COATED FLUSH STEEL DOOR (1h FIRE-RATED) COLOR TO CLIENT APPROVAL

HARDWARE SET
3No. STAINLESS STEEL HINGES WITH BALL BEARING
2No. STAINLESS STEEL LEVER HANDLES.
1No. LEVER LOCKSET WITH DEAD BOLT AND LATCH.
1No. CYLINDER LOCK WITH 3 KEYS

GLAZING OR VIEW PANEL 10mm THICK TEMPERED GLASS
OPENING HINGED AND FIXED

NOTES USED FOR BASEMENT

Plot No. Basin No. Basin name The village

Client Name
الشركة العامة الاردنية للصوامع والتموين المساهمة العامة المحدودة.
Project Name

DETAILS 1

Project number 306

Date Issue Date


Design by :Arch.Shahed 218190

Checked by : Arch.Suhail 200097

A112

Scale 1:100

COLUMNS SCHEDULE AND DETAILS

NO. COLUMN	LEVEL	SIZE OF COLUMN	REINFORCEMENT		SECTION & STEEL DETAILS	
			VERTICAL REINFORCEMENT	TIES		
C1	GROUND	NONE	NONE	NONE		HE280B

Vanzulla Company For Consulting
Engineering Designs
(2824)
Tel- 0789695422

CODE OF PRACTICE

Bearing capacity of the soil at the foundation level = 3.20 kg/cm2.

DEPTH OF FOOTING = 1.00m from the surrounding level.

- JORDANIAN CODE (JS-1997) AND SPECIFICATIONS.

- CODE OF BASIC DATA FOR THE DESIGN OF BUILDING & CALCULATE WIND LOAD (ASCE07-10 & JORDANIAN CODE)

- AMERICAN INSTITUTE OF STEEL CONSTRUCTION-AISC, LOAD RESISTANCE FACTOR DESIGN -LRFD

A COPY OF LATEST EDITION OF THESE DOCUMENTS SHALL BE KEPT AT SITE AT ALL TIMES DURING CONSTRUCTION.

DIMENSIONS

4.3 Bolts :

All Dimensions are in centimeters unless noted.

STRUCTURAL DESIGN LOADS:

RESIDENTIAL AREA:
- SUPER IMPOSED DEAD LOADS 0.445 KN/M2
self-weight of steel structure
- LIVE LOAD 0.60KN/M2
- WIND LOADS USING ASCE07-10 "SAP2000"
Maximum WIND SPEED = 35m/s=78.5Mph

Material Properties (Material Used in Steel structure) :

ASTM A36 with yield stress 248MPa for Rolled Steel Section.

ASTM A653(M) with yield stress 275MPa for Cold Form Sections.

EYILED STRENTH OF STEEL=420MPA

SLAB LOADS HANKER STEEL ELEVATION1

Super Impose Dead Load = 0.445 kN/m2=0.445*6.0=2.67kN/m
SNOW Load = 905-400/320=1.58*0.8=1.264kN/m=1.264*6.00=7.584kN/m
LIVE LOAD =0.60kN/m2 ...snow load is covern
WINDWARD WALL = +0.49192*6.0=2.95 kN/m
LEEWARD WALL = -0.34606*6.0=-2.07kN/m
UPWARD ROOF = -0.54054*6=-3.243 kN/m
SIDEWARD WALL= -0.4433x6=-2.67 kN/m

- SEISMIC DATA/AS PER ASCE07-10 HANKER STEEL

BUILDING FRAME SYSTEM	ADMINISTRATION BUILDING
STEEL BUCKLING RESTRAINED BRACED FRAME	
DUCTILE (R)	NONE
Fa,Fv SOIL TYPE	NONE
OVERSTRENGTH FACTOR	NONE
SEISMIC COEFFICIENT	NONE
SEISMIC COEFFICIENT	NONE
IMPORTANCE FACTOR	NONE
AMPLIFICATION FACTOR	NONE

DESIGN AND DETAILING CODES SHALL BE ACCORDING TO:

- JCRC - 2022 : JORDAN CODE FOR NORMAL AND REINFORCED CONCRETE./ACI(318-14)
- JCLF - 06 : JORDAN CODE FOR LOADS AND FORCES.
- JSC - 2022 : JORDAN SEISMIC CODE./IBC2012+ASCE07-10
- JSC - 2022 : JORDANIAN METAL CODE


كودة المباني المقاومه لزلزال الجزء الثاني "الباب الثامن"
التصميم الزلازلي للمنشآت الفولاذيه
كودة الانشاءات الفولاذيه من كودة البناء الوطني

Plot No.	Basin No.	Basin name	The village

Client Name
الشركة العامة الاردنية للصوامع والتموين المساهمة
العامة المحدودة.
Project Name

GENERAL DETAILS

Project number	303
Date	Issue Date
Design by :	SALEM AHMAD
Checked by :	NAJEH KANAAN
S01	
Scale	1:100

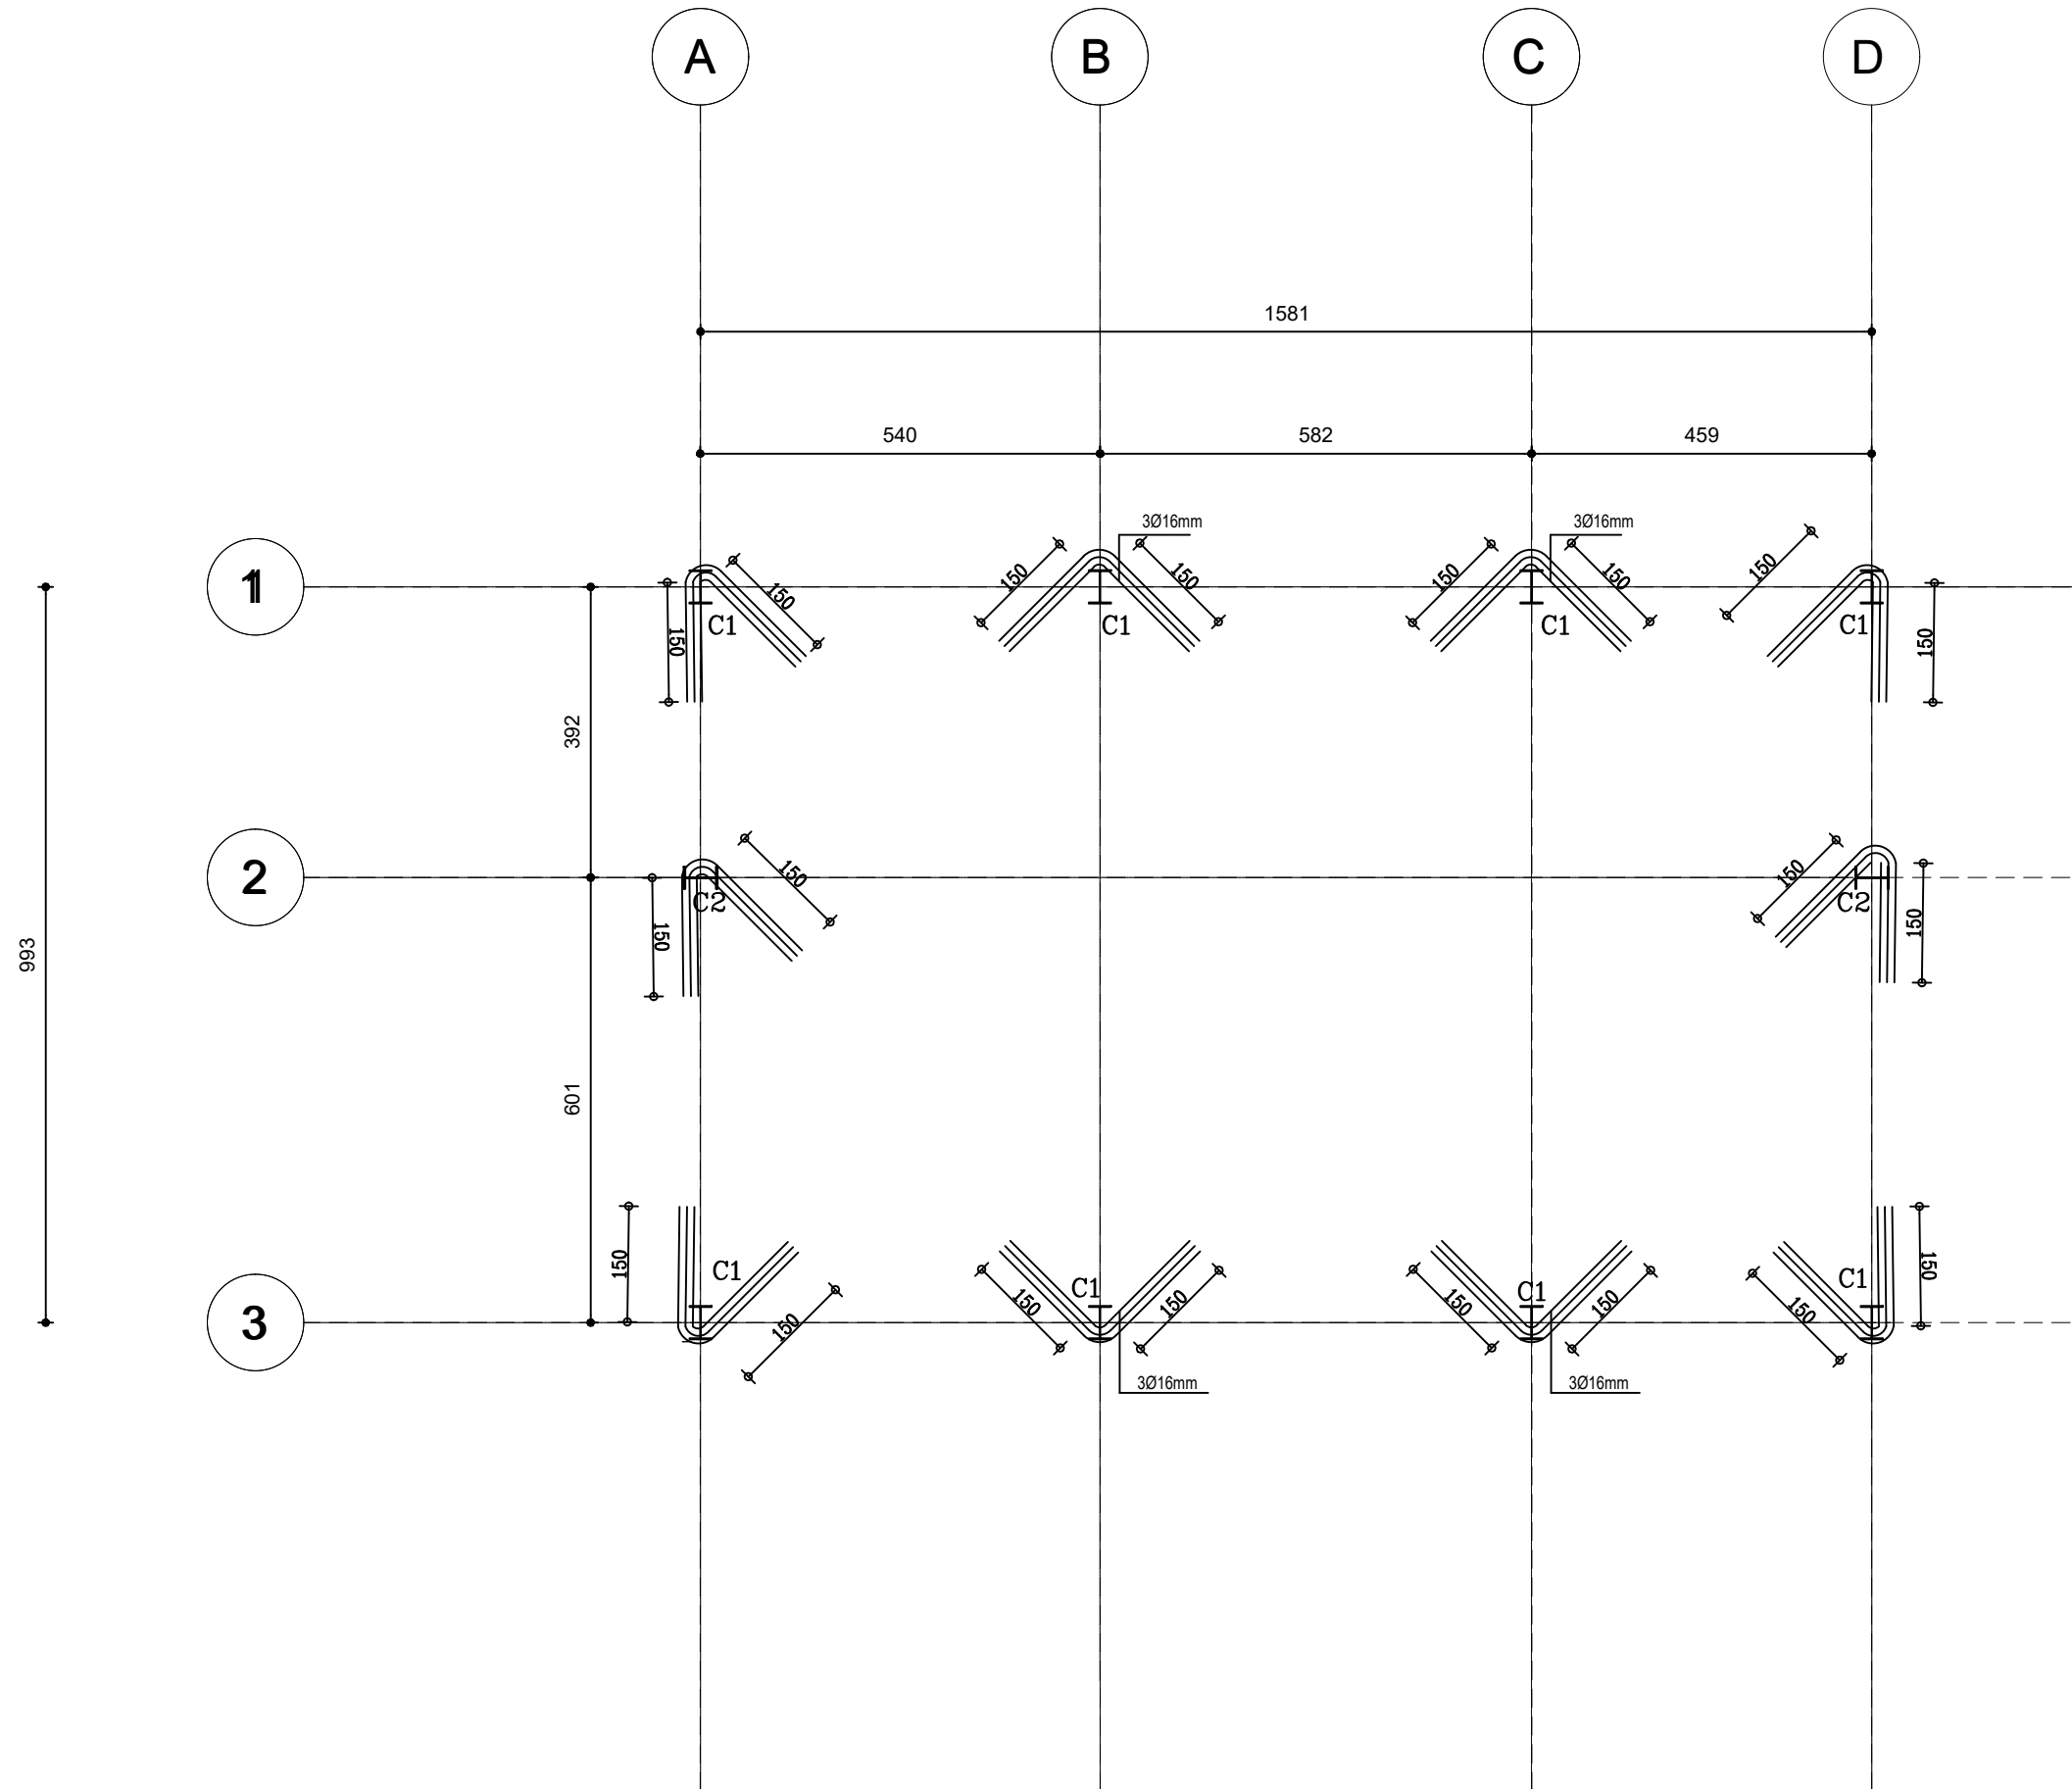

COLUMNS AXISES LAYOUT

Vanzulla Company For Consulting
Engineering Designs
(2824)
Tel- 0789695422

Plot No.	Basin No.	Basin name	The village

Client Name
الشركة العامة الاردنية للصوامع والتموين المساهمة
العامة المحدودة.
Project Name

COLUMNS AXISES LAYOUT

Project number 303


Date Issue Date

Design by : SALEM AHMAD

Checked by :NAJEH KANAAN

S02

Scale 1:100

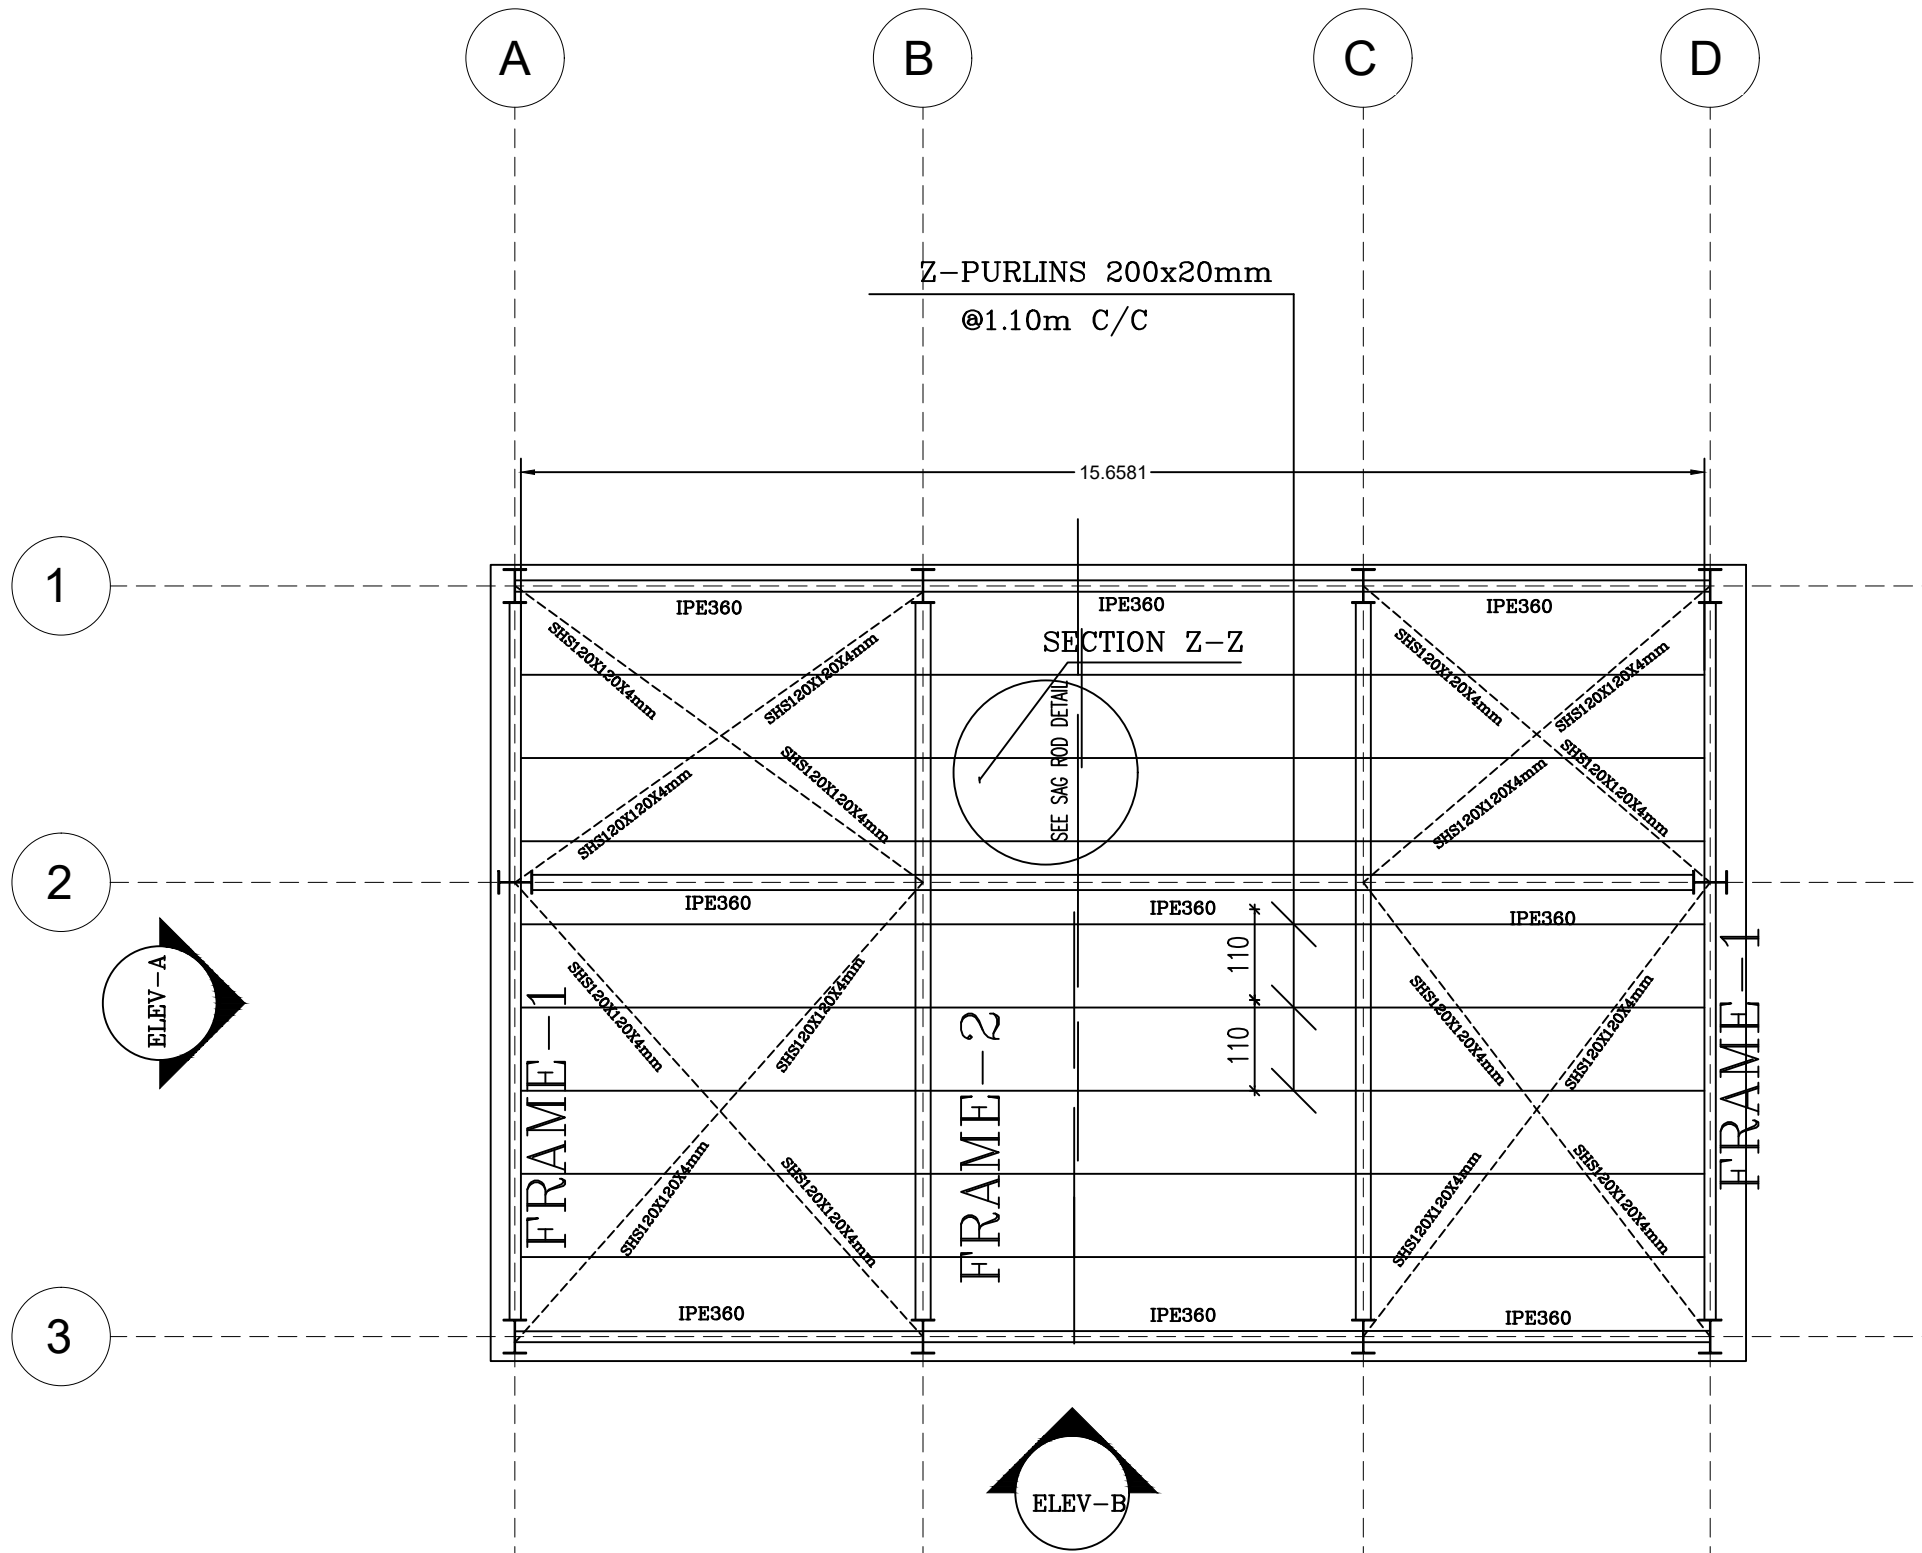

HANKER STEEL PLAN

Plot No.	Basin No.	Basin name	The village

Client Name
الشركة العامة الأردنية للصوامع والتموين المساهمة
العامة المحدودة.
Project Name

HANKER STEEL LAYOUT

Project number 303







Date Issue Date

Design by : SALEM AHMAD

Checked by : NAJEH KANAAN

S03

Scale 1:100

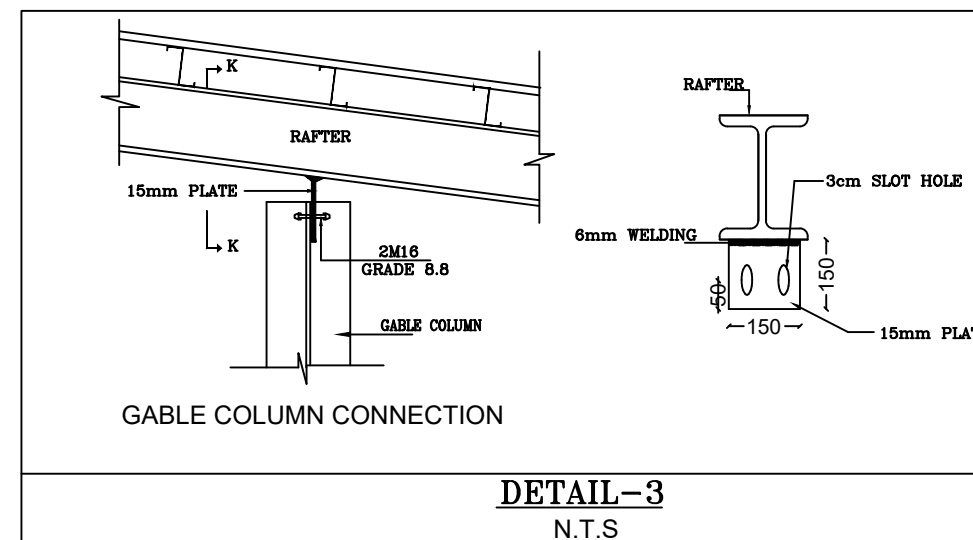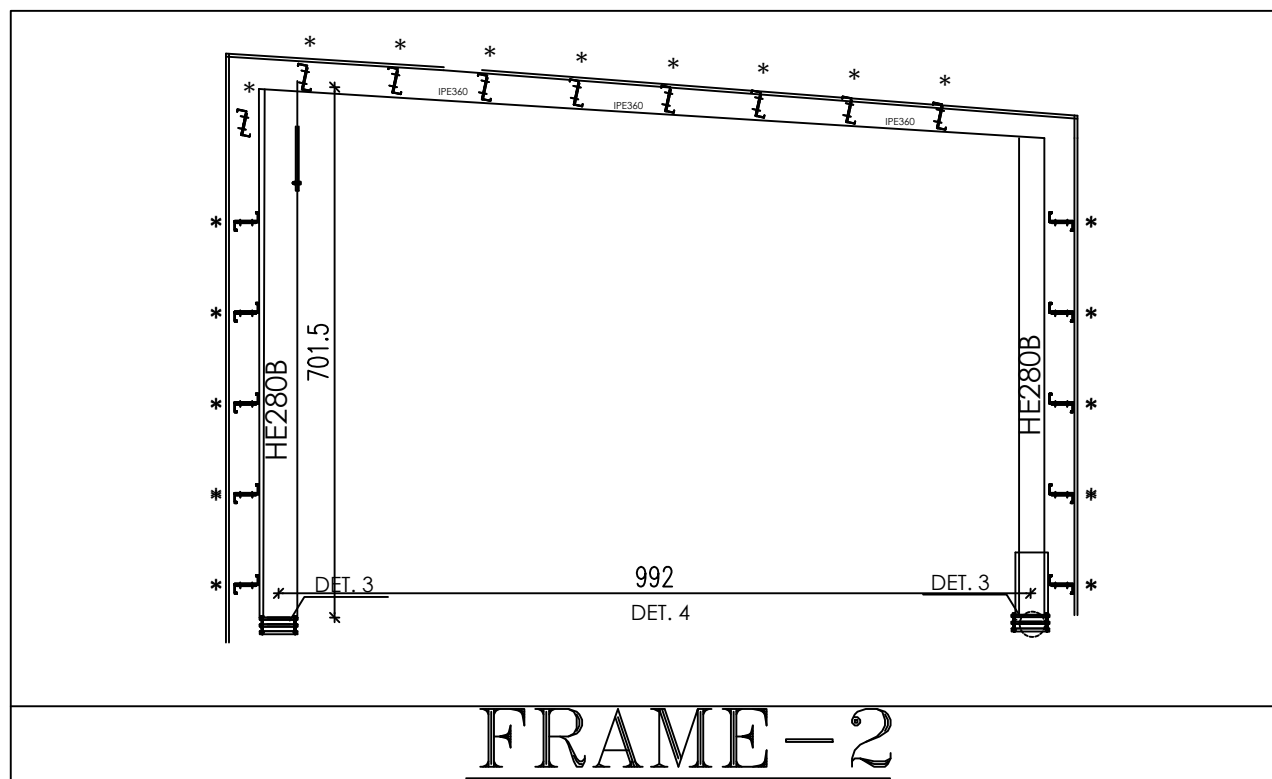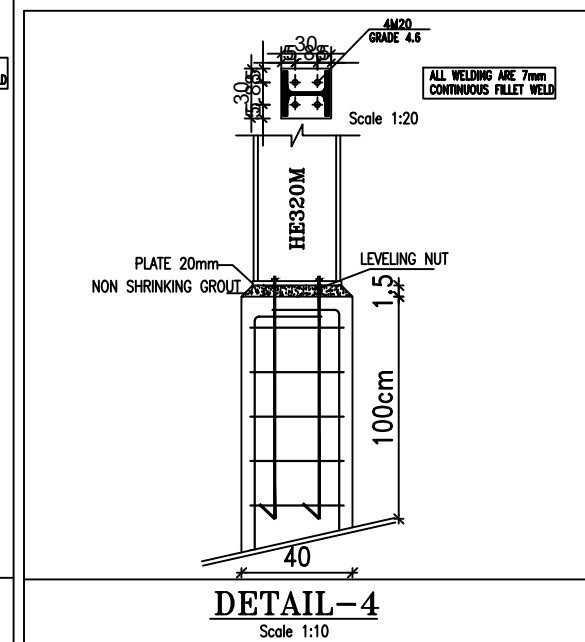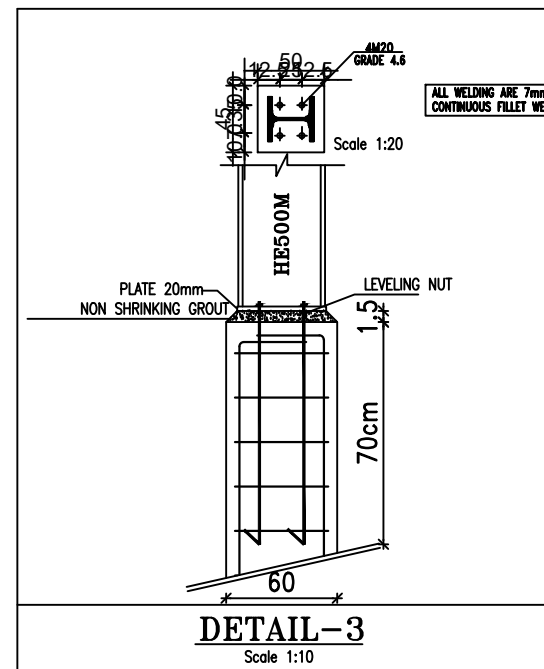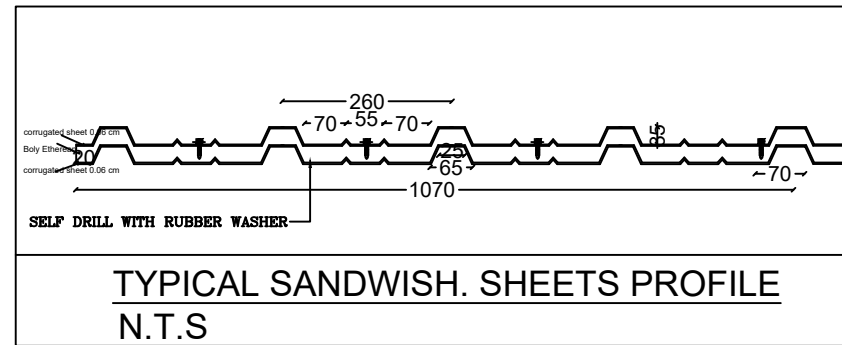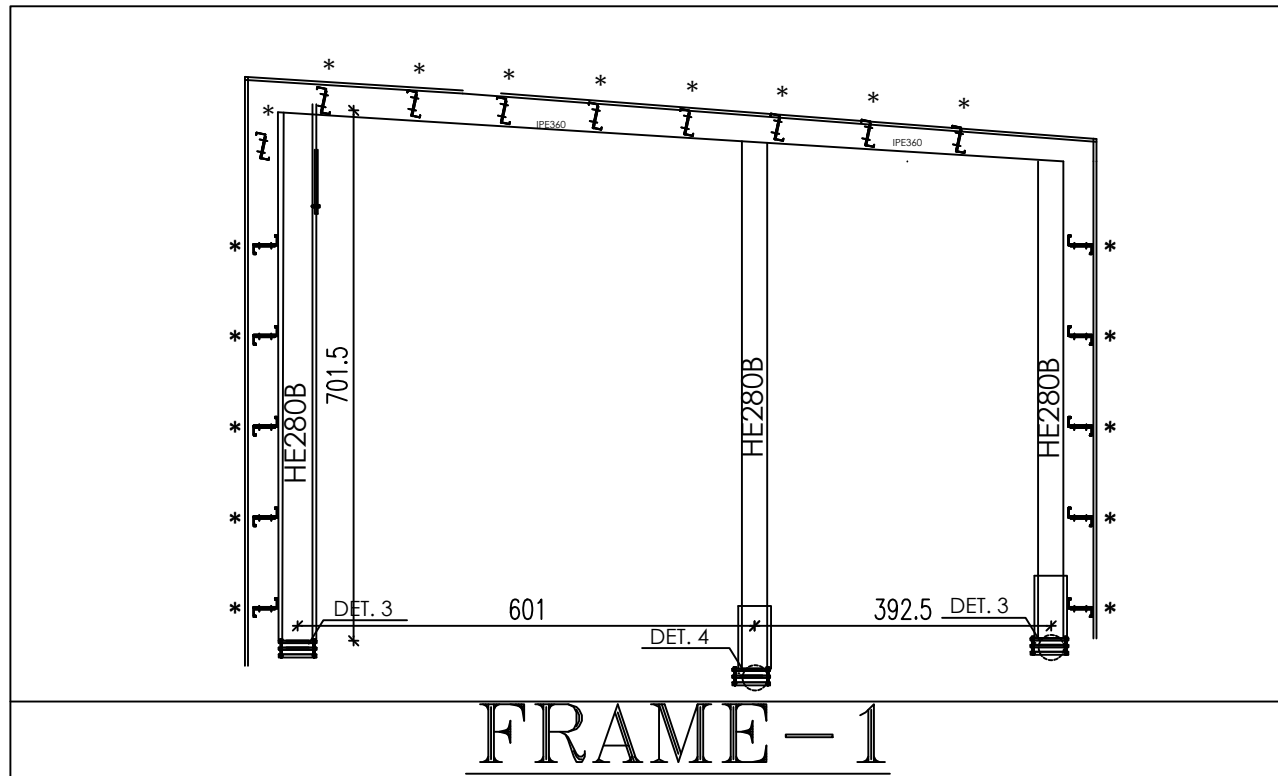

Vanzulla Company For Consulting
Engineering Designs
(2824)
Tel- 0789695422

Plot No.	Basin No.	Basin name	The village

Client Name
الشركة العامة الاردنية للصوامع والتموين المساهمة
العامة المحدودة.
Project Name

STEEL CONNECTION DETAILS

Project number 303


Date Issue Date

Design by : SALEM AHMAD


Checked by : NAJEH KANAAN

S04



Scale 1:100

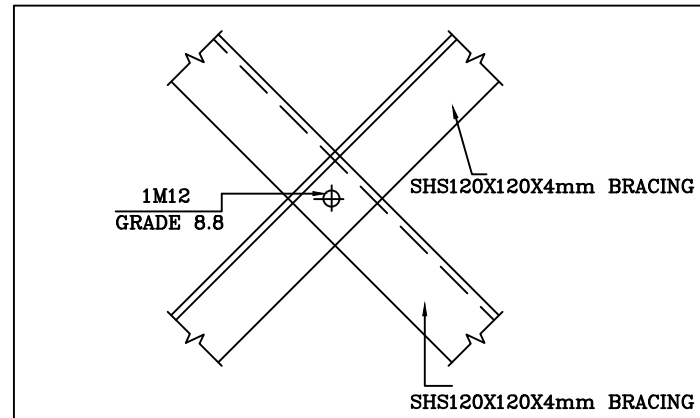


BRACING INTERSECTION DETAILS
N.T.S

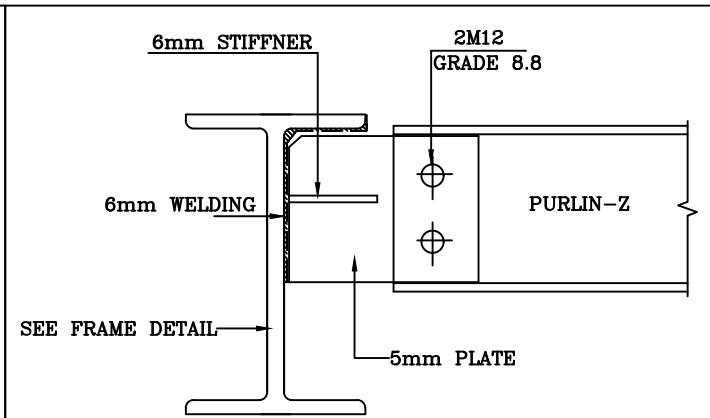


PURLIN JOINT WITH COLUMN
N.T.S

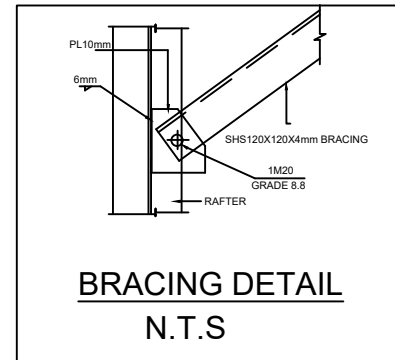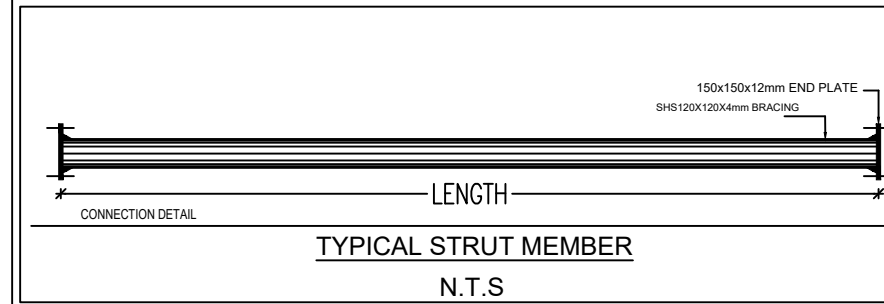



BRACING DETAIL
N.T.S

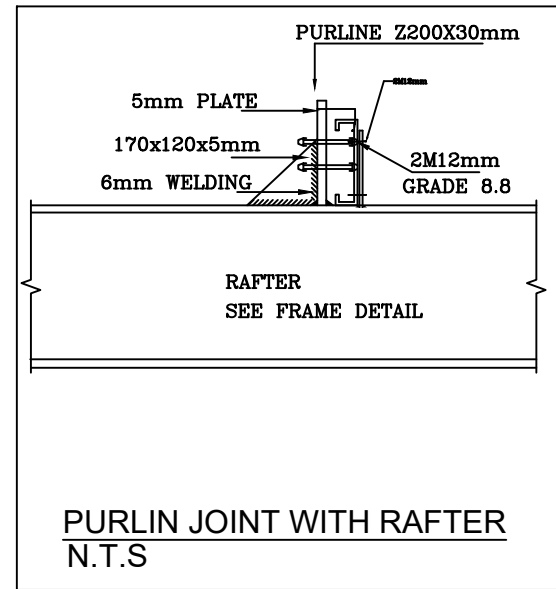

PURLIN JOINT WITH RAFTER
N.T.S

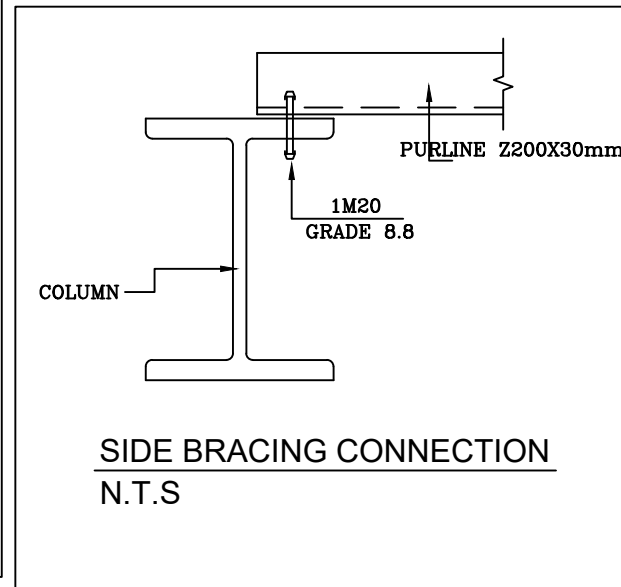

SIDE BRACING CONNECTION
N.T.S

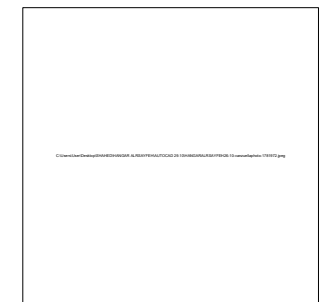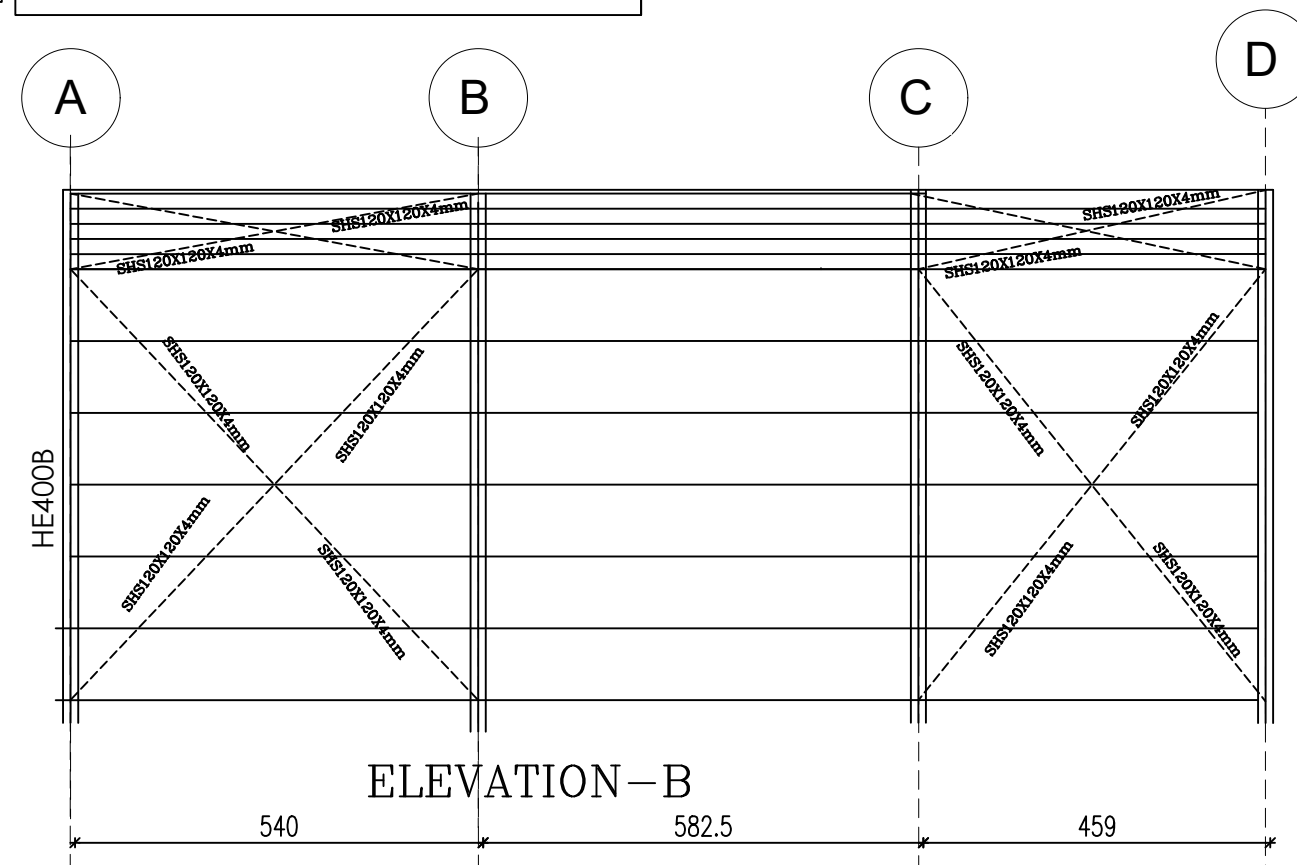

Vanzulla Company For Consulting
Engineering Designs
(2824)
Tel- 0789695422

Plot No.	Basin No.	Basin name	The village

Client Name
الشركة العامة الاردنية للصوامع والتموين المساهمة
العامة المحدودة.
Project Name

STEEL CONNECTION DETAILS

Project number 303

Date Issue Date




















Design by : SALEM AHMAD


 


 







 



Checked by : NAJEH KANAAN

S05

Scale 1:100

ELEC. SYMBOLS POWER Schedule

SYMBOL	DESCRIPTION
 D.B.	FINAL DISTRIBUTION BOARD (DB)
 S.M.D.B.	SUB Main Distribution Board.
 M.T.C.	Main Telephone Terminal Box.
 T.J.B. 10 PAIR	Sub Main Telephone Terminal Box
	BELL (BELL PUSH BUTTON) .
	13A SINGLE PHASE, 3-PIN SOCKET OUTLET, IP-20. AT LEVEL 2.5m.
	16A DOUBLE POLE SWITCH WITH PILOT LAMP, FOR E.W.H
	16A INDUSTRIAL SOCKET, 3-PIN, 230V WITH PLUG & LOCKABLE COVER
	32A INDUSTRIAL SOCKET, 5-PIN, 400V WITH PLUG & LOCKABLE COVER
	10A, ONE GANG -, TWO GANG, THREE GANG ONE WAY SWITCH.
	10A, ONE GANG -, TWO GANG - TWO WAY SWITCH.
	3-POLE, 13Amp. SWITCHED SOCKET OUTLET, WITH PILOT LIGHT.
	3-POLE, 16Amp. SWITCHED SOCKET OUTLET
	2- GANG, 3-POLE, 13Amp. SWITCHED SOCKET OUTLET, WITH PILOT LIGHT.
	TELEPHONE SOCKET OUTLET (RJ11).
	T.V. AND SATELLITE SYSTEM SOCKET OUTLET
	ELECTRIC WATER HEATER (SEE MECH. DWG. FOR DET. & SPECIFICATION).
	SPN, ISOLATING SWITCH, IP-65 (FOR RATING REFER TO DRAWINGS).
	TPN, ISOLATING SWITCH, IP-65 (FOR RATING REFER TO DRAWINGS).

SYMBOL	DESCRIPTION
	72W SURFACE MOUNTED LED LIGHTING FIXTURE BUTTIN TYPE ,IP20 Light Efficiency=6500LM,Input voltage:85~265V AC Dimension: 600*1200*9mm
	40W SURFACE MOUNTED LED LIGHTING FIXTURE BUTTIN TYPE ,IP20 BUTTIN TYPE ,IP20,Light Efficiency=4000LM Input voltage:85~265V ,ACDimension:300*1200*9mm
	72W SURFACE MOUNTED LED LIGHTING FIXTURE BUTTIN TYPE ,IP20 Light Efficiency=6500LM,Input voltage:85~265V AC Dimension: 600*1200*9mm
	72W SURFACE MOUNTED LED LIGHTING FIXTURE WITH OPAL DIFFUSER ,IP20 Light Efficiency=6500LM,Input voltage:85~265V AC Dimension: 600*1200*9mm
	36W SURFACE MOUNTED LED LIGHTING FIXTURE WITH LOUVER ,IP20 Light Efficiency=3600LM,Input voltage:85~265V ACDimension:600*600mm
	LED LIGHTING FIXTURE 7W WALL MOMNTED ABOVE SINK MIRROR PLY OPAL GLASS WHITE DIE CAST ALUMINUM FILTER , IP44
	SURFACE MOUNTED ROUND SHAPE LED SPOT LIGHT 18W Light Efficiency=1440LM, Input voltage:85~265V AC Dimension: ϕ225x20mm IP30
	SURFACE MOUNTED ROUND SHAPE LED SPOT LIGHT 24W Light Efficiency=1920LM, Input voltage:85~265V AC Dimension: ϕ300x20mm, IP30
	P65, surface mounted light,round ceiling led 15 watt for bathroom light Lamp Luminous Flux(lm):1100 LM IP Rating: IP65 waterproof Dimension: ϕ200x20mm
	SPECIAL PRODUCTS 72W POLICARBONATE BODY WATER ROOF LED LIGHTING FIXTURE IP 65
	High Bay Lights LED Light Source: Lamp Power(W): 100 Lamp Luminous Flux(lm): 15000 IP Rating: IP65
	led street light 100W with aluminium alloy led street light housing
	Wall mounted led light fixture ip54, with 30w. lamp, & decorative black aluminium arm with base.
	30W Waterproof LED Floodlight with CE RoHS Approval IP Rating: IP65 Operating Voltage: 110-240V Lumens: 800lm
	1x8W LED SELF CONTAINED LIGHTING FIXTURE WITH BATTERIES FOR 3 HOURS MAIN SUPPLY FAILURE, For Ceiling Or Wall Mounting.
	Ditto,But Non-Maintained Eixt Sing.

Note:-

- * ALL Switches to be fixed at hight 125cm from F.F.L.
unless the switches beside beds at hight 70cm from F.F.L.
- * ALL Socket Outlets to be fixed at hight 35cm from F.F.L.
unless the following outlet
- * Sockets in the Kitchen.
Sockets for general use to be fixed at hight 110cm from F.F.L.
Sockets for Frezer and refrigerator to be fixed at hight 210cm .

Vanzulla Company For Consulting
Engineering Designs
(2824)
Tel -0789695422

Plot No	Basin No	Basin name	The village

Client Name
الشركة العامة الاردنية للصوامع والتأمين المساهمة
العامة المحدودة.
Project Name

SITE PLAN

Project number 303

Date Issue Date


Design by :Arch.Shahed 218190

Checked by :Arch.Suhail 200097

E 1

Scale 1:100

PROPOSED HANGAR CONTAIN : PROPOSED (GROUND FLOOR)

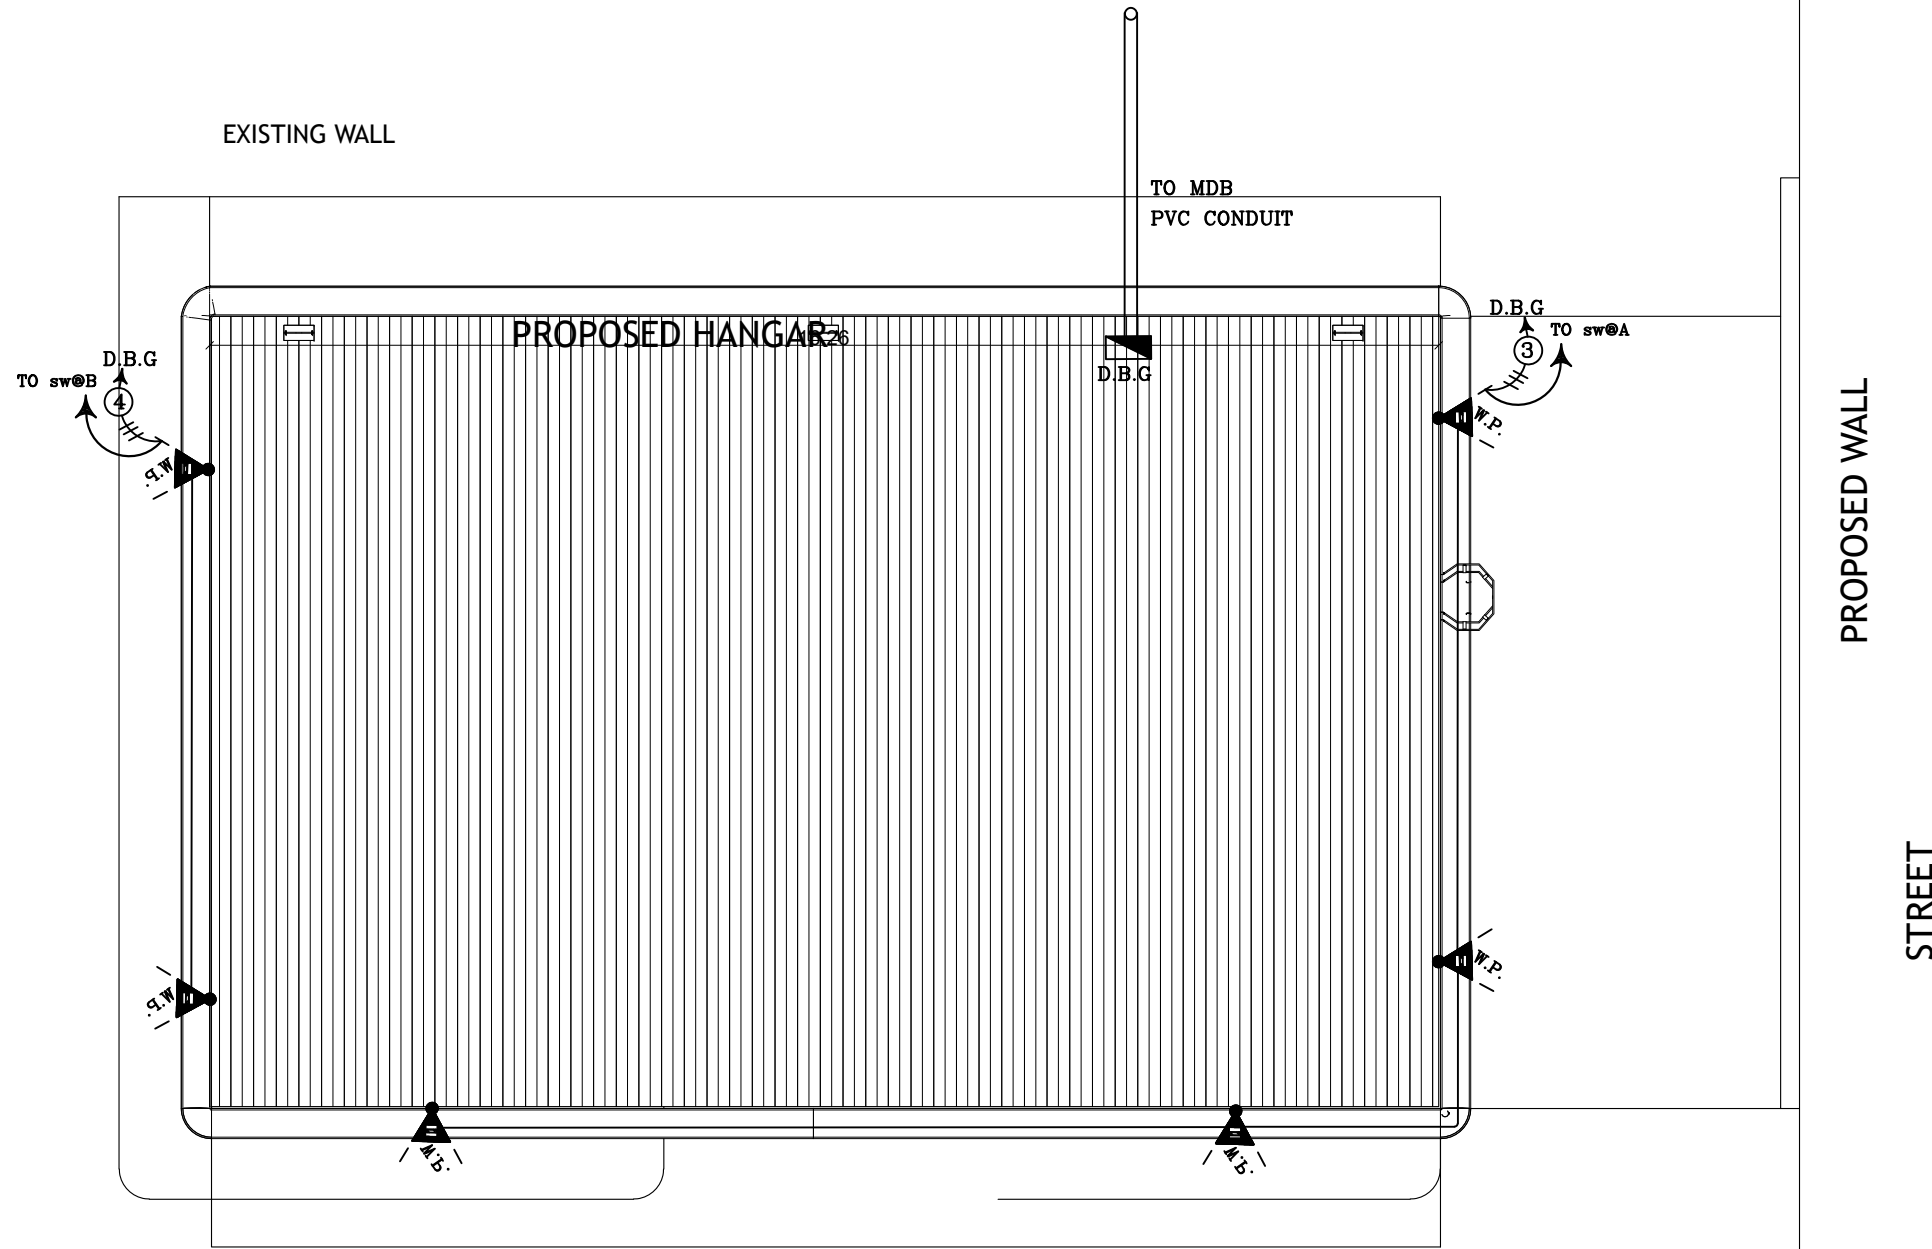

Vanzulla Company For Consulting
Engineering Designs
(2824)
Tel -0789695422

Plot No	Basin No	Basin name	The village

Client Name
الشركة العامة الاردنية للصوامع والتأمين المساهمة
العامة المحدودة.
Project Name

SITE PLAN

Project number 303

Date Issue Date


Design by :Arch.Shahed 218190

Checked by :Arch.Suhail 200097

E 2

Scale 1:100

EXISTING SIDEWALK

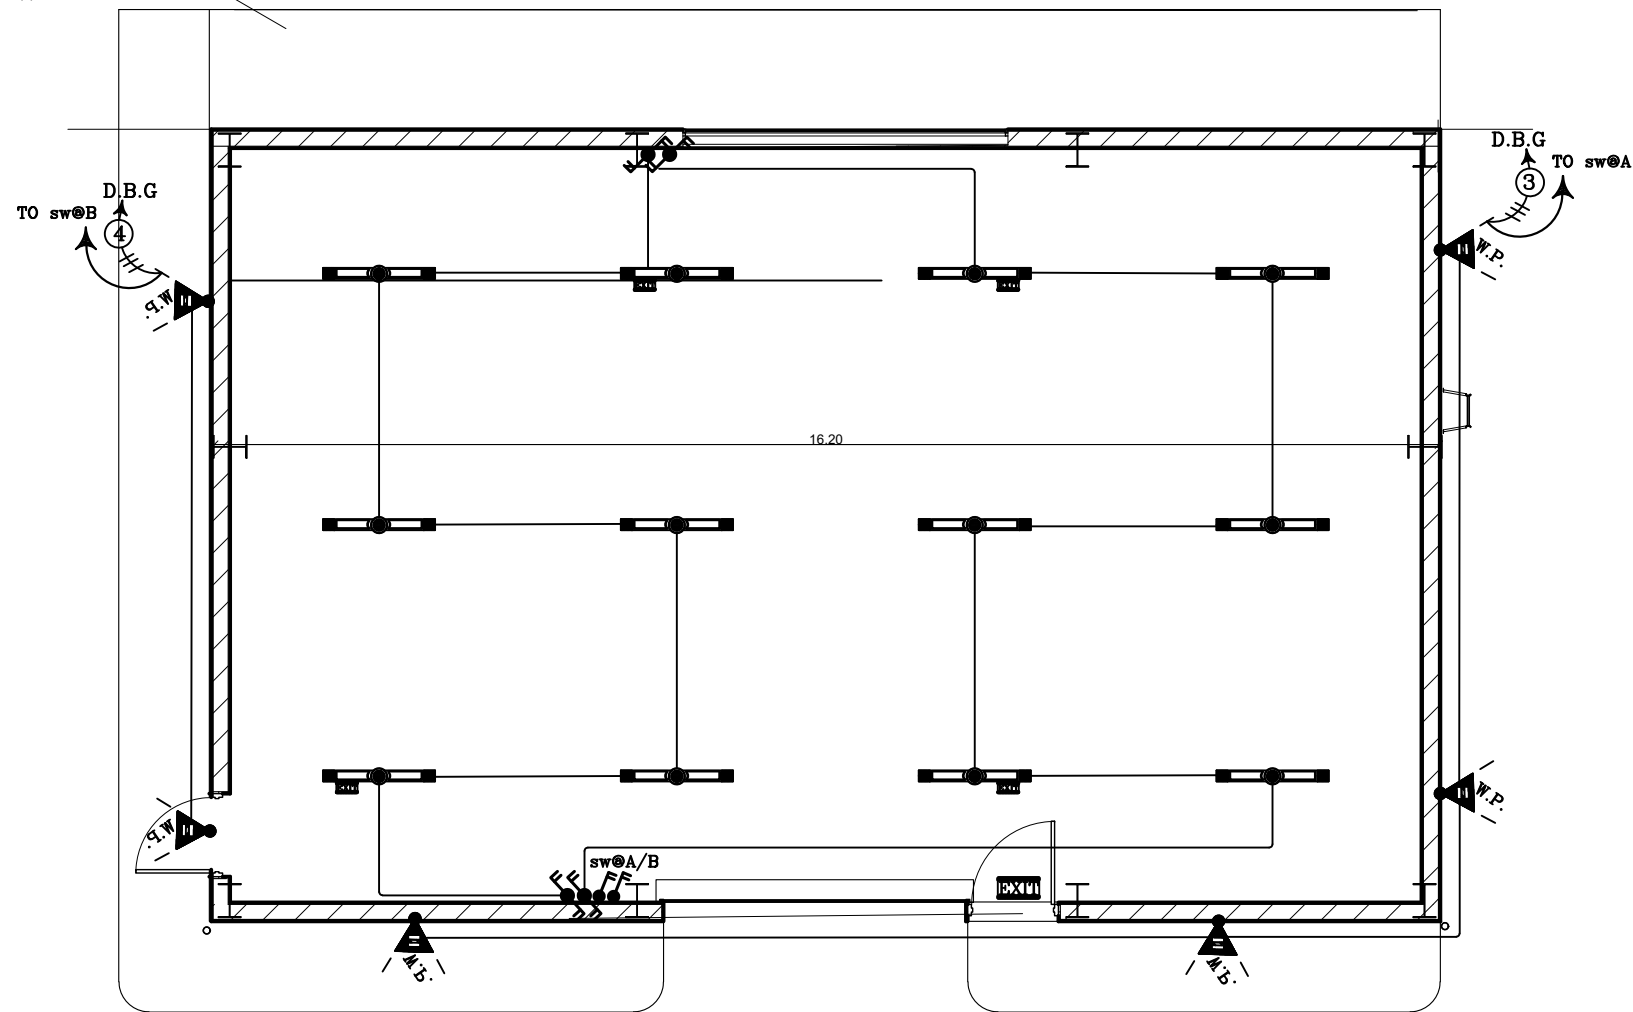

Vanzulla Company For Consulting
Engineering Designs
(2824)
Tel -0789695422

Plot No	Basin No	Basin name	The village

Client Name
الشركة العامة الأردنية للصوامع والتأمين المساهمة
العامة المحدودة.
Project Name

GROUND FLOOR

Project number 303

Date Issue Date


Design by :Arch.Shahed 218190

Checked by :Arch.Suhail 200097

E 3

Scale 1:100

EXISTING SIDEWALK

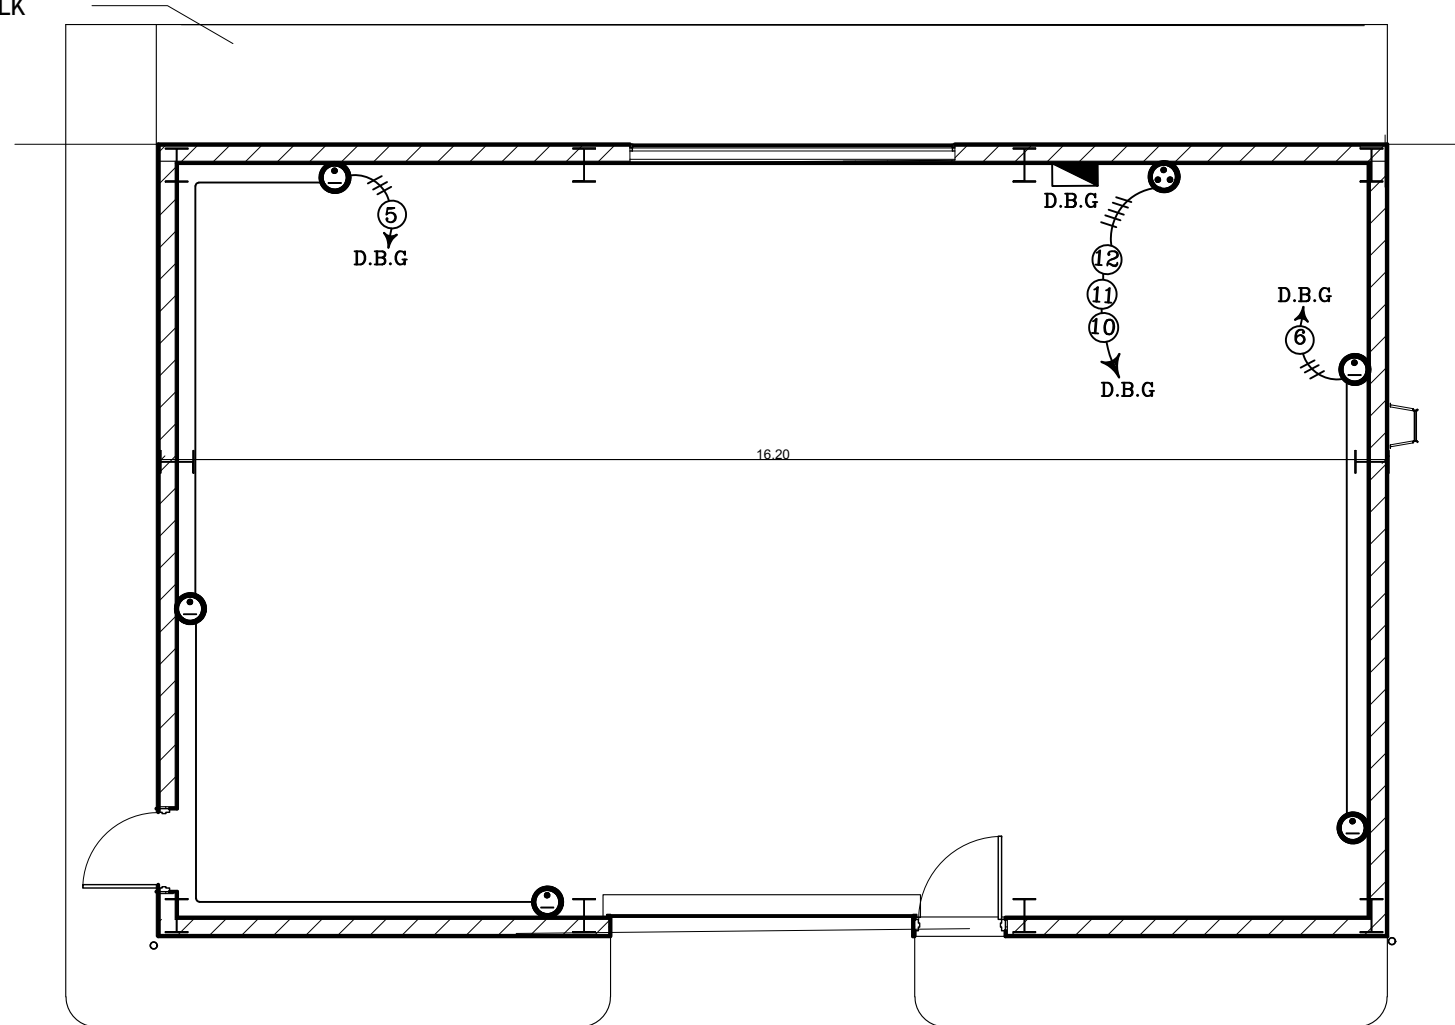

Vanzulla Company For Consulting
Engineering Designs
(2824)
Tel -0789695422

Plot No	Basin No	Basin name	The village

Client Name
الشركة العامة الاردنية للصوامع والتأمين المساهمة
العامة المحدودة.
Project Name

GROUND FLOOR

Project number 303


Date Issue Date

Design by :Arch.Shahed 218190

Checked by :Arch.Suhail 200097

E 4

Scale 1:100

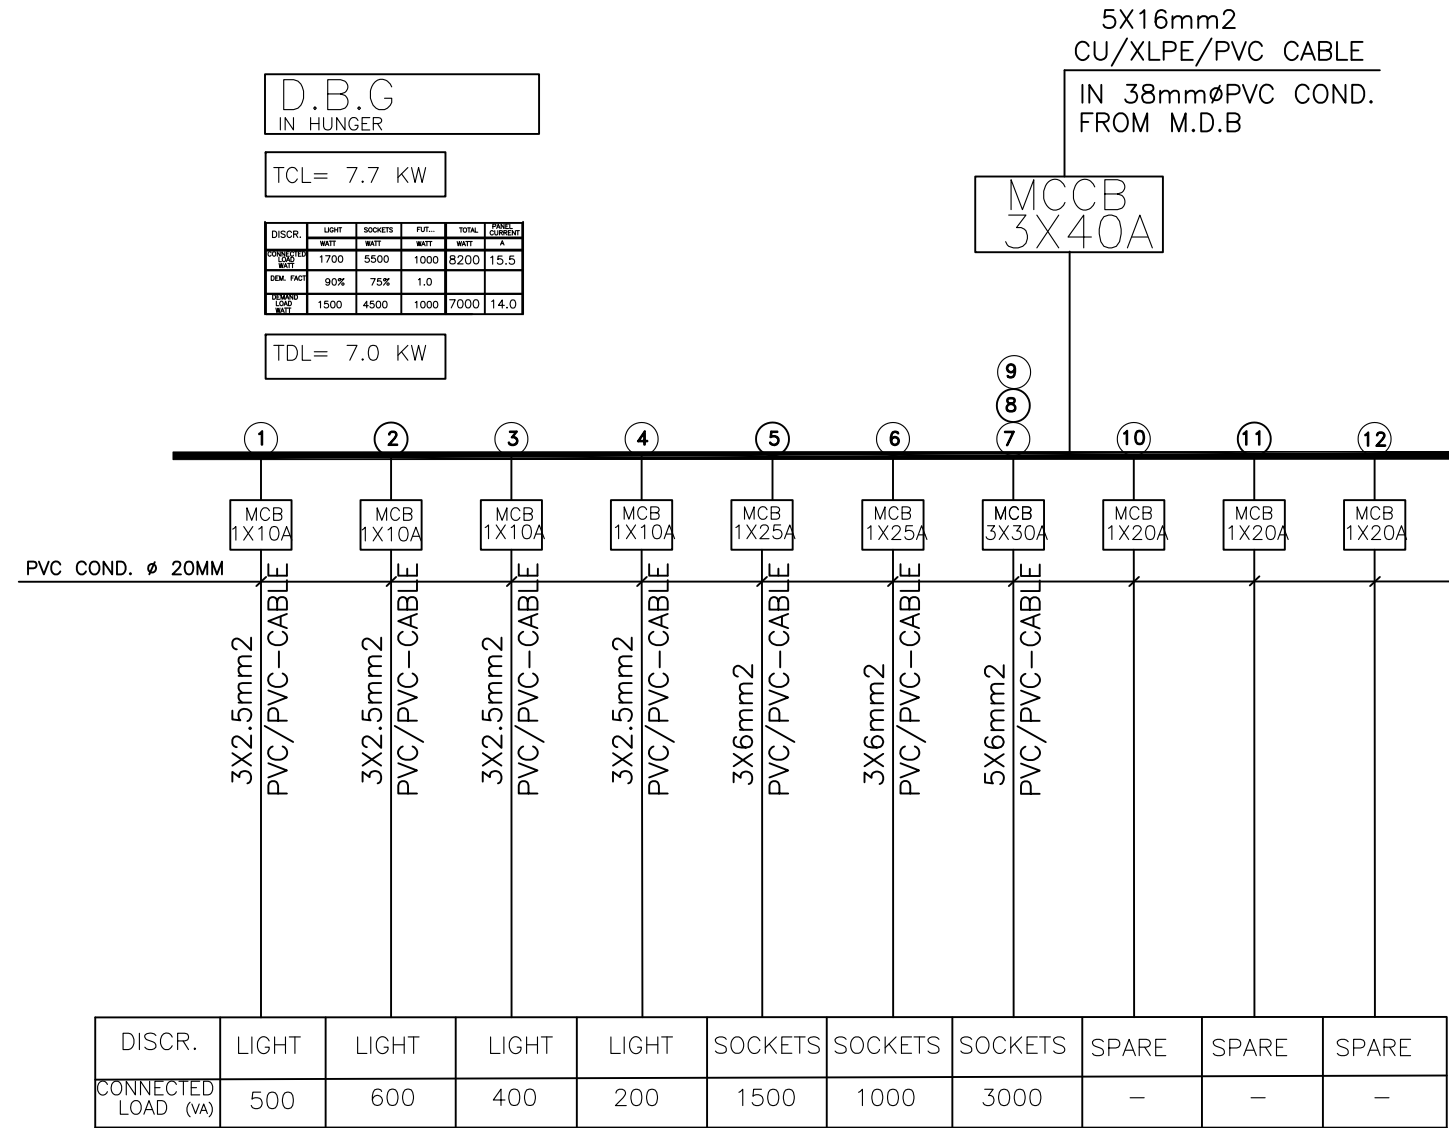

Plot No	Basin No	Basin name	The village

Client Name
الشركة العامة الاردنية للصوامع والتموين المساهمة
العامة المحدودة.
Project Name

GROUND FLOOR

Project number 303

Date Issue Date








Design by :Arch.Shahed 218190

Checked by :Arch.Suhail 200097


E 5

Scale 1:100

   ROOF FLOOR

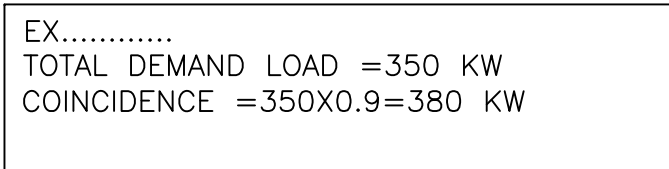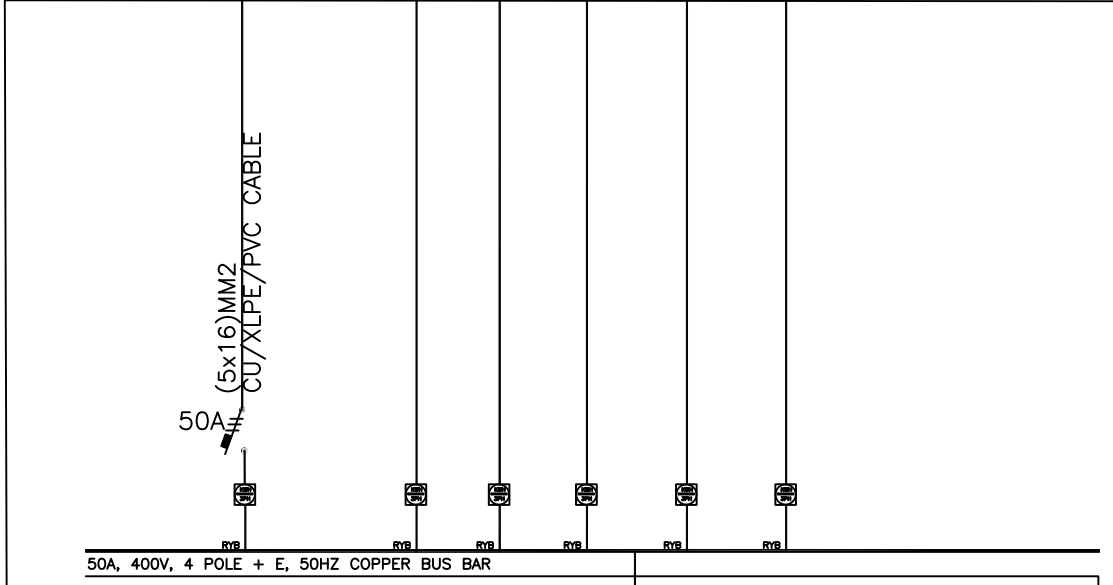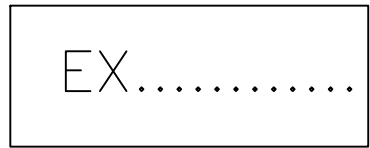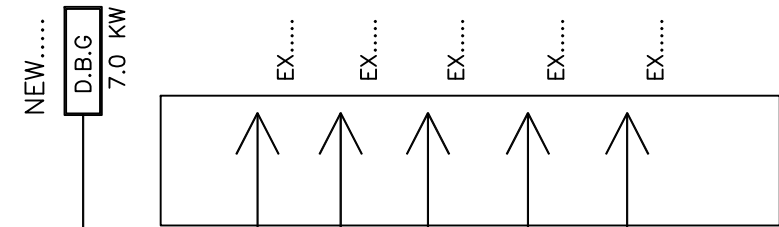

 800X800X900mm CONCRETE MANHOL.WITH H.D COVER.



ENTRY MAIN EL. CABEL FROM J.E.P.Co.
4X120mm2 CU/XLPE /SWA/PVC
in 110mm DUCT TO JEPCO NETWORK

GROUND FLOOR

POWER RISER DIAGRAM

Vanzulla Company For Consulting
Engineering Designs
(2824)
Tel -0789695422

Plot No	Basin No	Basin name	The village

Client Name
الشركة العامة الاردنية للصوامع والتأمين المساهمة
العامة المحدودة.
Project Name

GROUND FLOOR

Project number 303

Date Issue Date


Design by :Arch.Shahed 218190

Checked by :Arch.Suhail 200097

E 6

Scale 1:100

EXISTING SIDEWALK

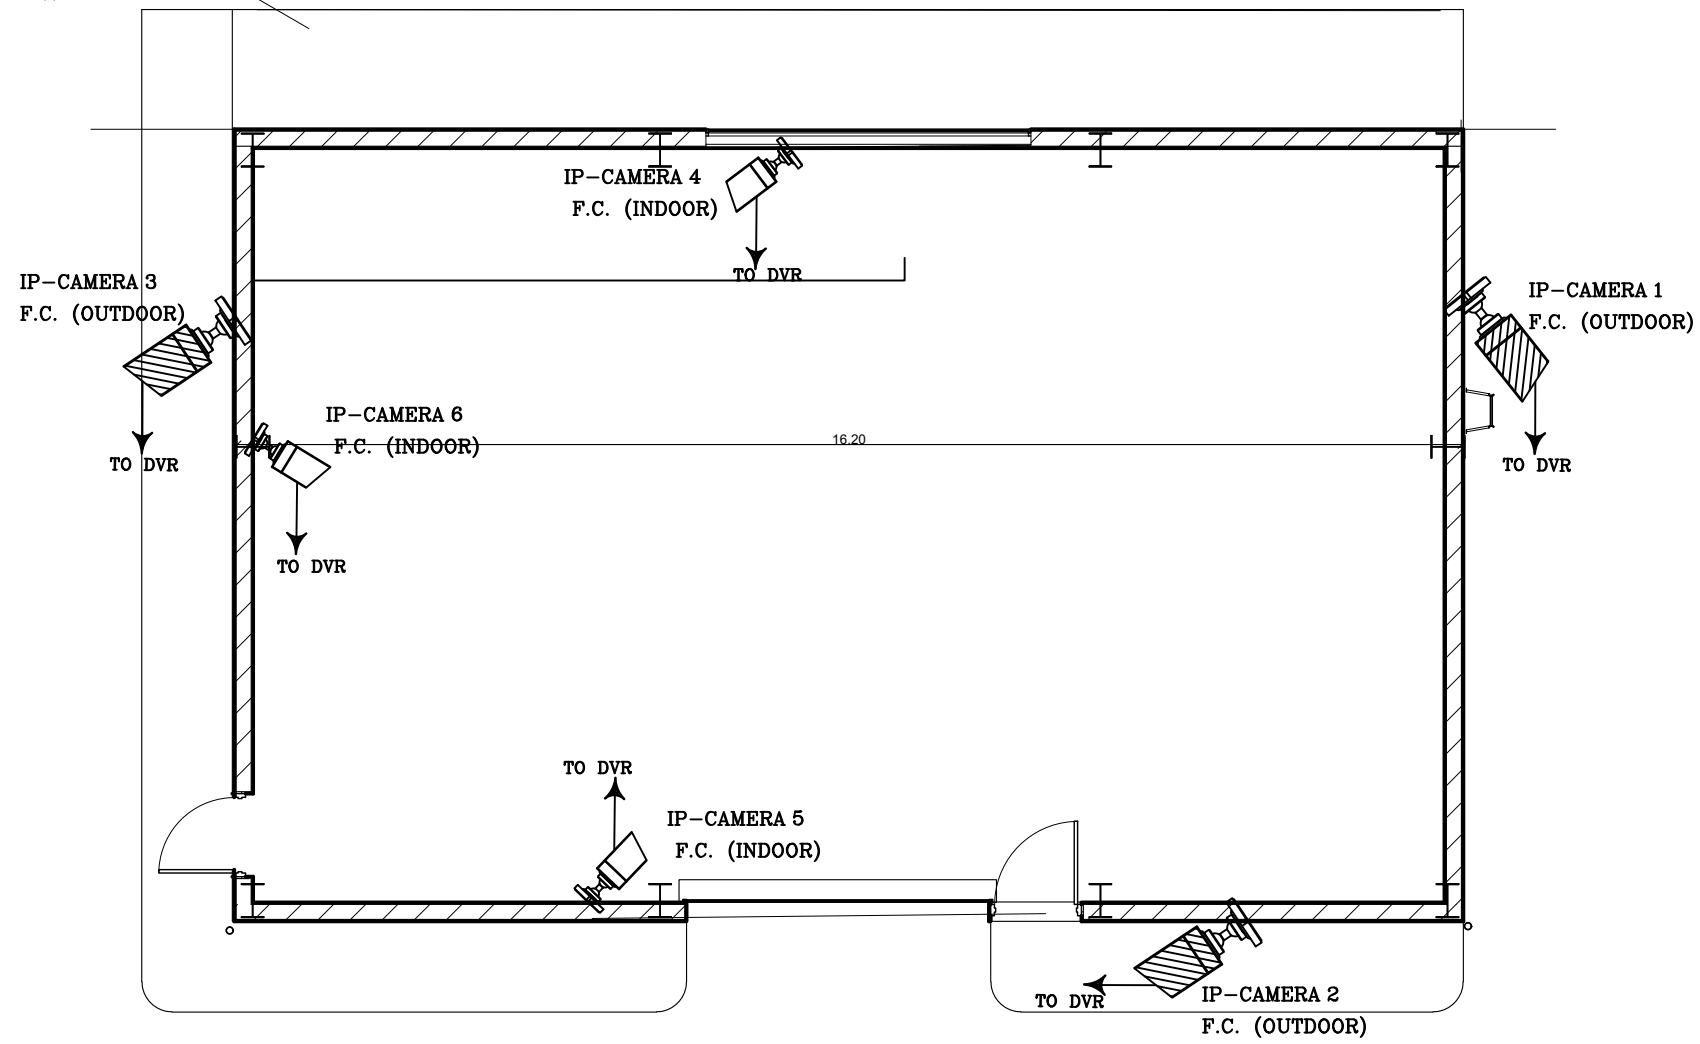

Vanzulla Company For Consulting
Engineering Designs
(2824)
Tel -0789695422

Plot No	Basin No	Basin name	The village

Client Name
الشركة العامة الاردنية للصوامع والتأمين المساهمة
العامة المحدودة.
Project Name

GROUND FLOOR

Project number 303

Date Issue Date

Design by :Arch.Shahed 218190


Checked by :Arch.Suhail 200097

E 7

Scale 1:100

RESOLUTION CAMERA > 720 p

NOTE : DVR MUST RECORDING NOT LESS THAN 31 DAYS @ 25 FPS

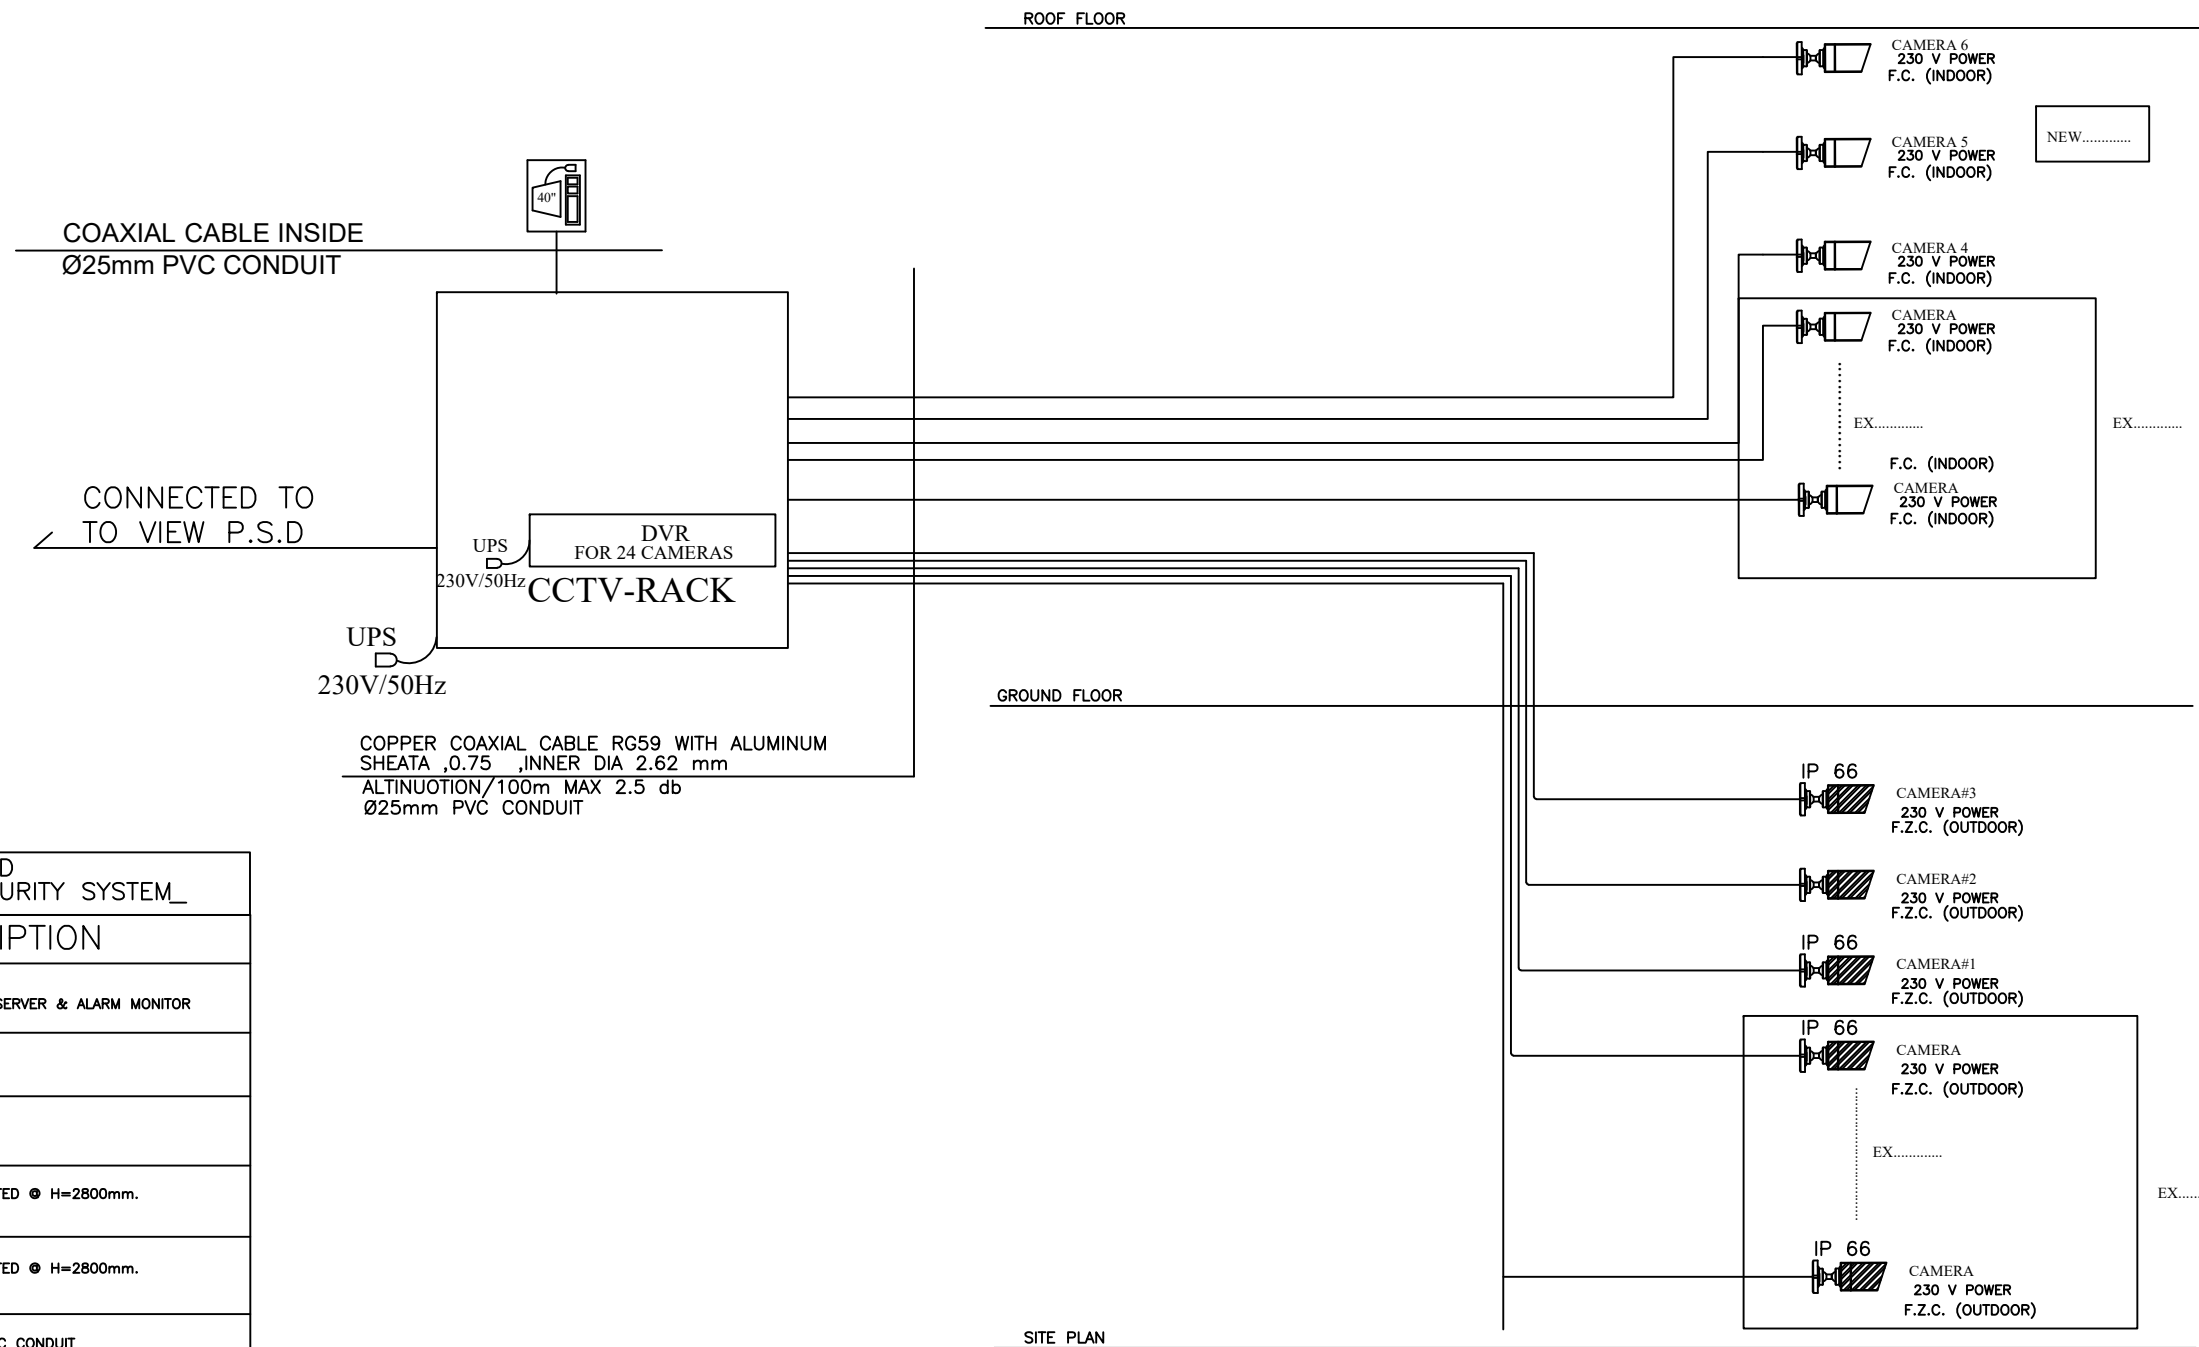

LEGEND LOW CURRENT CCTV SECURITY SYSTEM	
SYMBOL	DESCRIPTION
	CCTV RACK CCTV MATRIX SWITCHER & VIDEO SERVER & ALARM MONITOR
	DIGITAL VIDEO RECORDER
	MONITOR
	CCTV FIXED CAMERA WALL MOUNTED ● H=2800mm. OUTDOOR W.P TYPE IP 66
	CCTV FIXED CAMERA WALL MOUNTED ● H=2800mm. INDOOR W.P TYPE
	COAXIAL CABLE INSIDE Ø25mm PVC CONDUIT

NOTE : DVR MUST RECORDING NOT LESS THAN 31 DAYS @ 25 FPS

NOTE : IMAGING SPEED NOT LESS THAN 25 PHOTOS PER SECOND

Vanzulla Company For Consulting
Engineering Designs
(2824)
Tel -0789695422

Plot No	Basin No	Basin name	The village

Client Name
الشركة العامة الأردنية للصوامع والتأمين المساهمة
العامة المحدودة.
Project Name

GROUND FLOOR

Project number 303

Date Issue Date


Design by :Arch.Shahed 218190

Checked by :Arch.Suhail 200097

E 8

Scale 1:100

EXISTING SIDEWALK

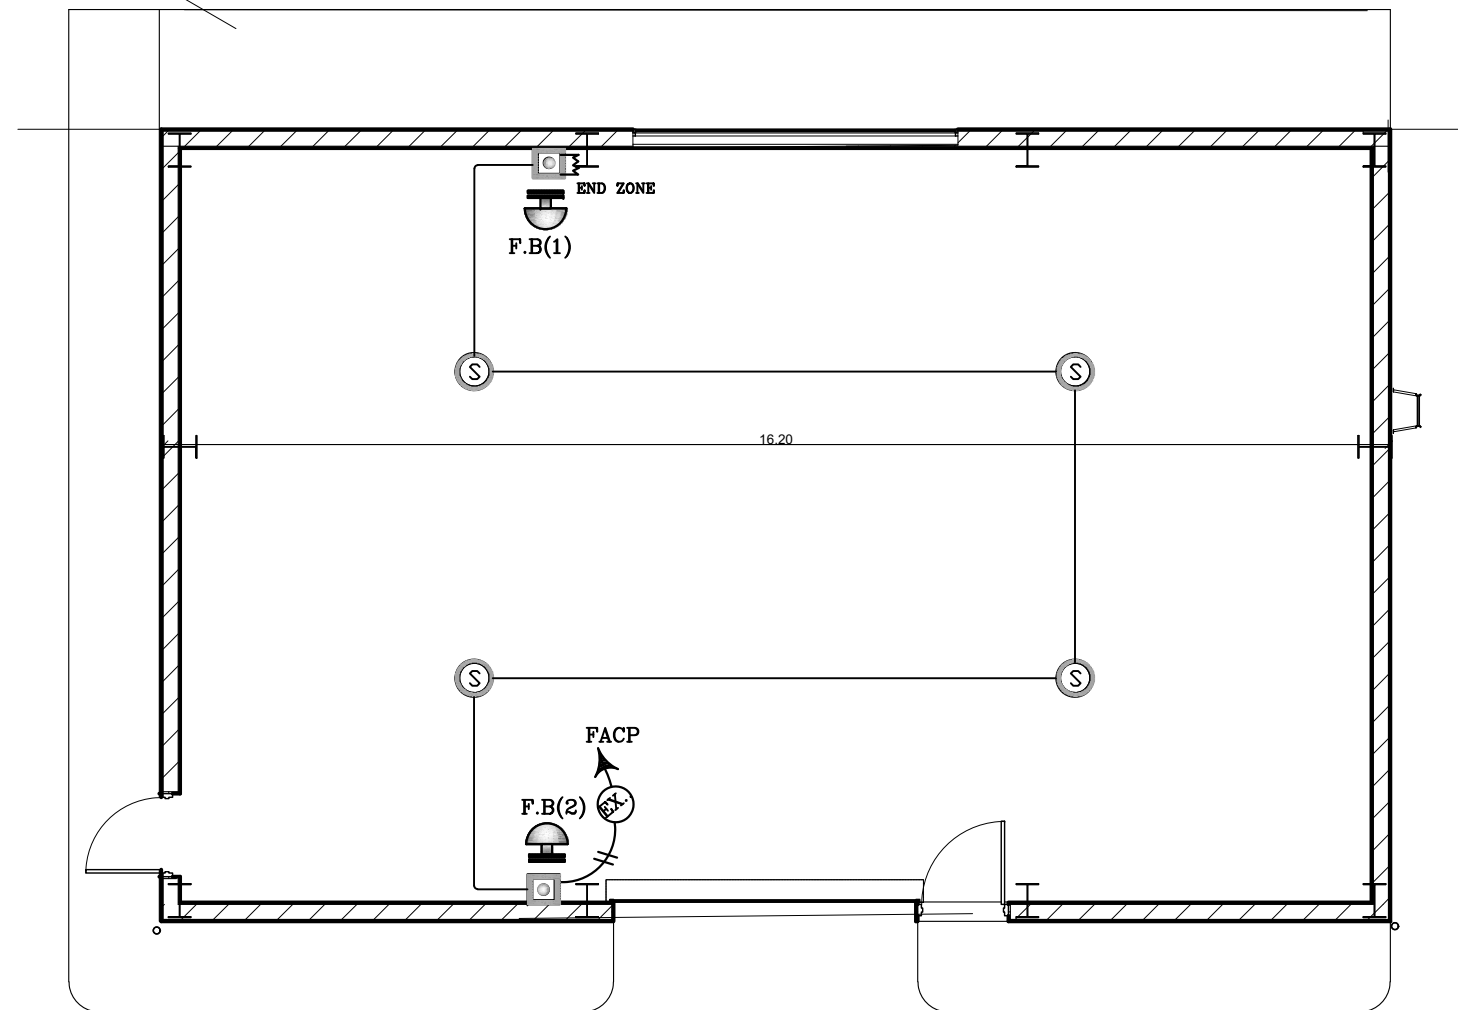

Vanzulla Company For Consulting
Engineering Designs
(2824)
Tel -0789695422

Plot No	Basin No	Basin name	The village

Client Name
الشركة العامة الاردنية للصوامع والتأمين المساهمة
العامة المحدودة.
Project Name

GROUND FLOOR

Project number 303

Date Issue Date

Design by :Arch.Shahed 218190

Checked by :Arch.Suhail 200097

E 9

Scale 1:100

FIRE ALARM LEGEND


SYMBOL	DESCRIPTION
	FIRE ALARM CONTROL PANAL.
	SMOKE DETECTOR
	HEAT DETECTOR.
	OPTICAL DETECTOR
	SMOKE DETECTOR WITH SOUND BASE
	BREAK GLASS CALL AT 140cm AFFL.
	OUTDOOR ALARM FLASHER WITH SIREN
	INDOOR ALARM FLASHER

NOTE :

- *The alarm system is Conventional system.
- *The construction height from FFL:
 - FACP: 1.65m.
 - Break glass: 1.25m.
 - Flasher: 2.25m.
- *All the wires & cables used in Fire Alarm System, are fire retardant (resist fire for 30min. at least) in $\varnothing 20$ PVC conduits, which they are:
 - Detector loop: 2x1.5 Cu\PVC cable.
 - Flasher Bell Circuit: 2x2.5 cable.
- *The height above False Ceiling is Less than 80cm and the false ceiling material is fire retardant.

Vanzulla Company For Consulting
Engineering Designs
(2824)
Tel -0789695422

ROOF FLOOR

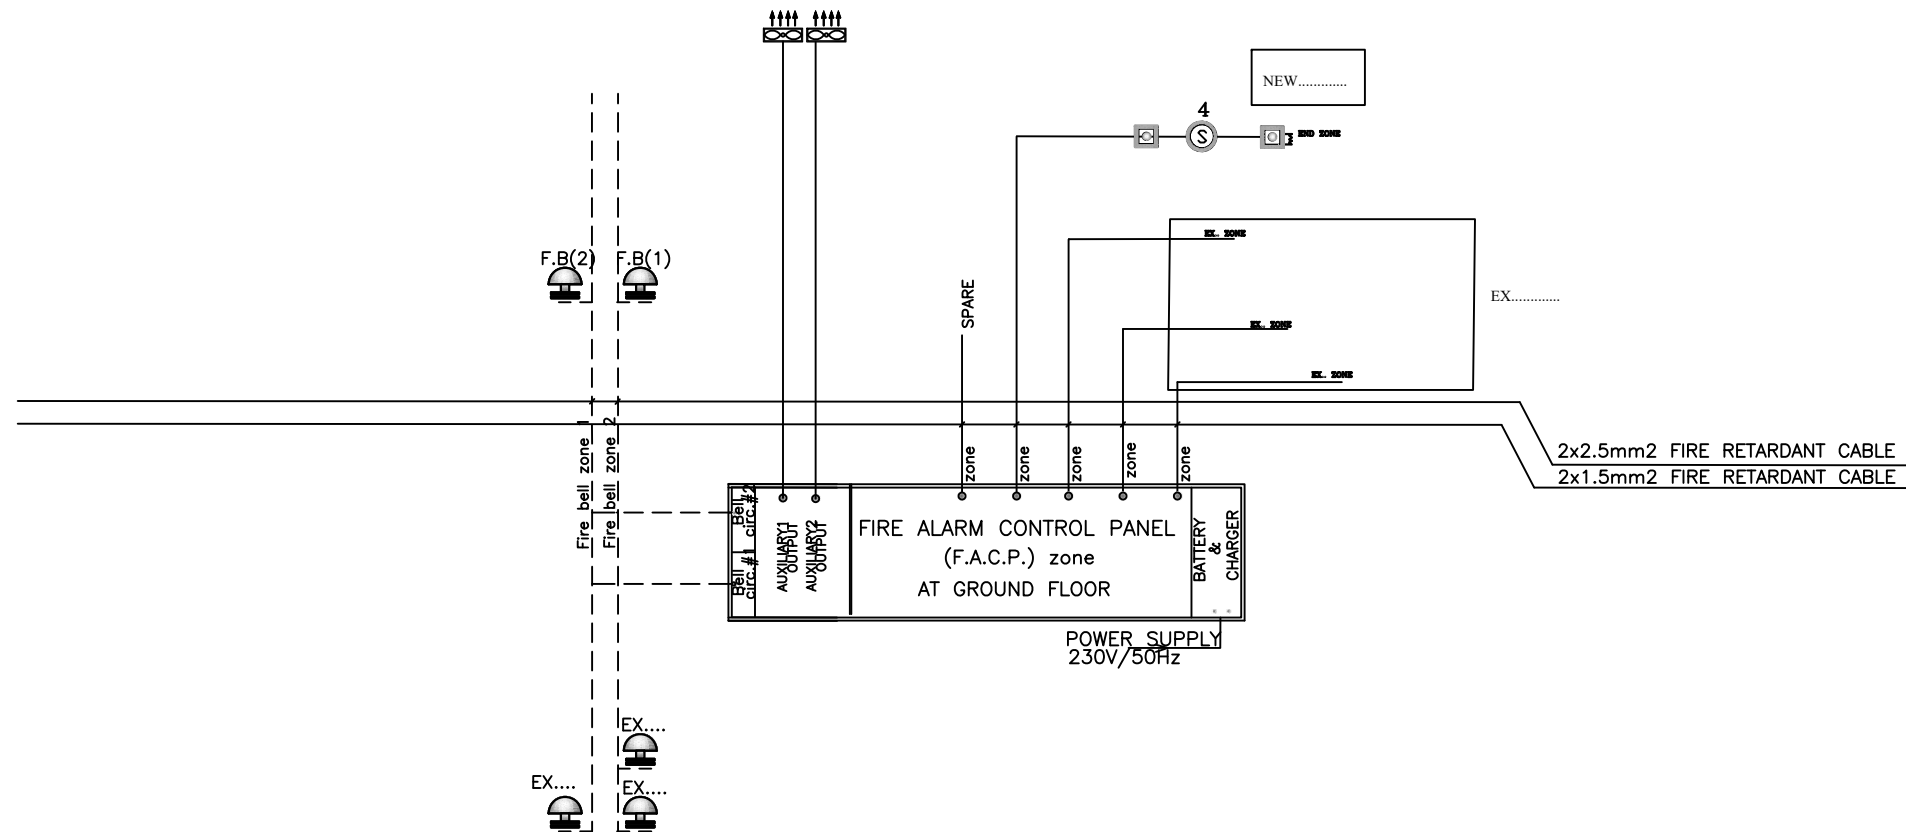

GROUND FLOOR

CONVENTIONAL FIRE ALARM RISER DIAGRAM

Plot No	Basin No	Basin name	The village

Client Name
الشركة العامة الاردنية للصوامع والتأمين المساهمة
العامة المحدودة.
Project Name

GROUND FLOOR

Project number 303


Date Issue Date

Design by :Arch.Shahed 218190

Checked by :Arch.Suhail 200097


E 10

Scale 1:100

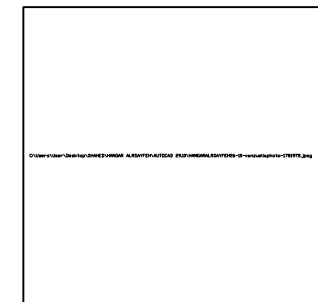

Vanzulla Company For Consulting
 Engineering Designs
 (2824)
 Tel- 0789695422

EXISTING SIDEWALK

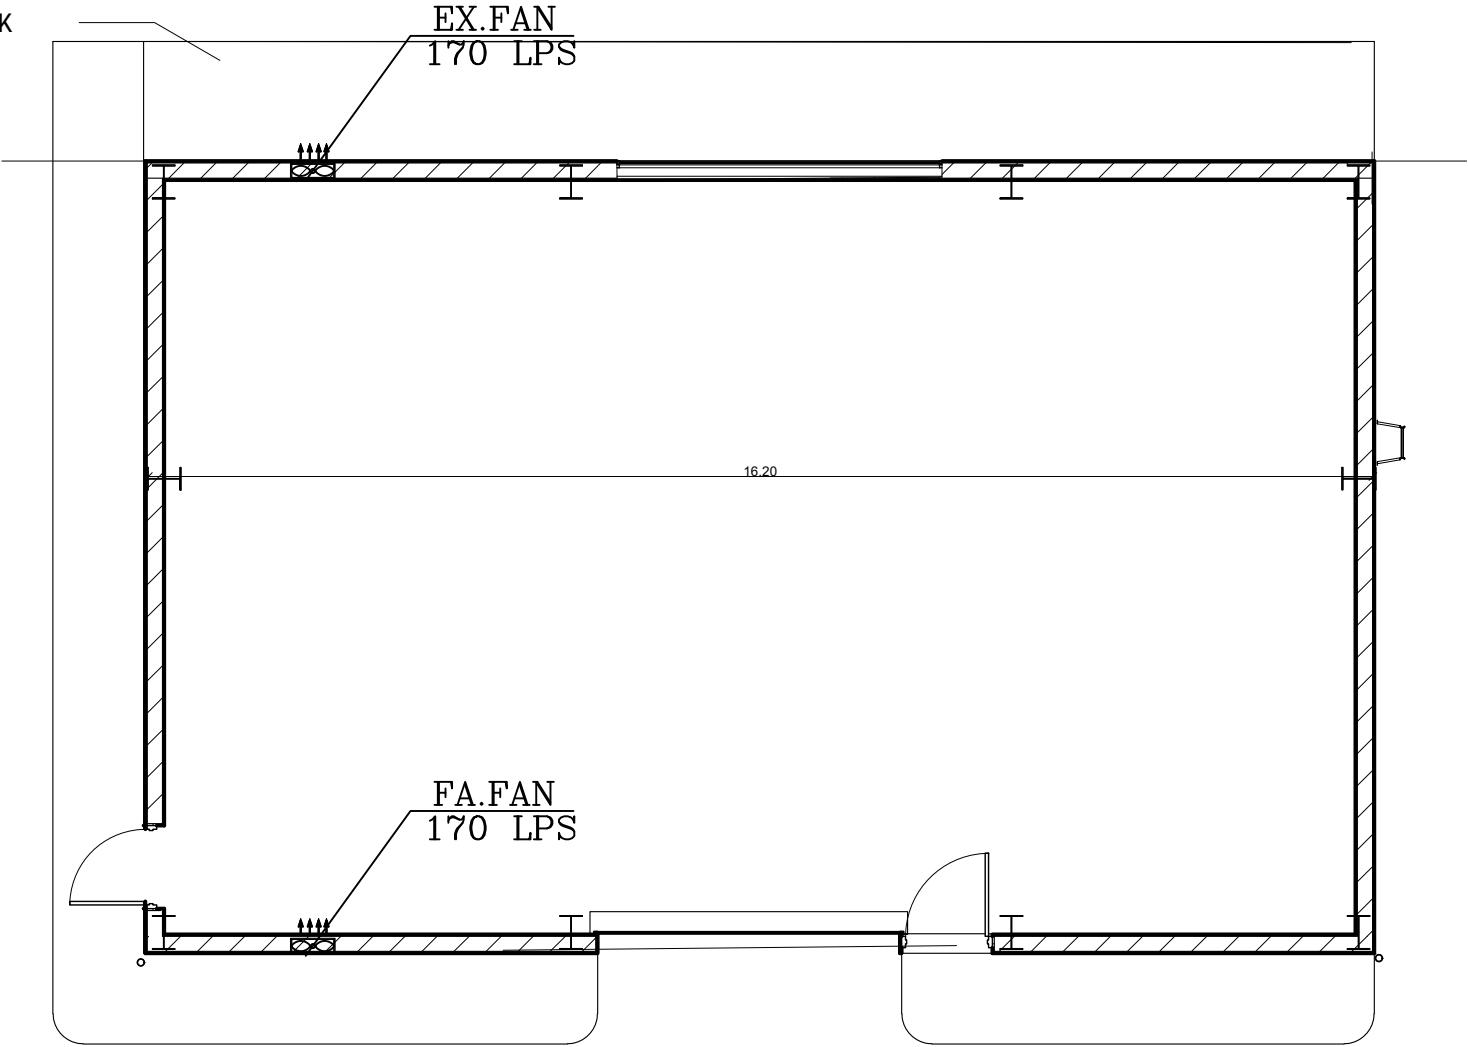

Plot No.	Basin No.	Basin name	The village

Client Name
 المساهمة والتعويض للصوامع الاردنية العامة الشركة
 المحدودة العامة
 Project Name

GROUND FLOOR
 AC

Project number 303

Date Issue Date

Design by :Azzam Attari 300760

Checked by : Azzam Attari 300760

M 101

Scale 1:100